



Appendix 3-A: Plan and Profile Drawings


CONTAINS REDACTED INFORMATION IN CASE 10-T-0139

CHPE - LAKE CHAMPLAIN PROPOSED CABLE ROUTE DRAWINGS EM&CP SEGMENT 18B

PREPARED FOR:
CALDWELL MARINE INTERNATIONAL (CMI)
 1333 CAMPUS PARKWAY
 WALL TOWNSHIP, NJ 07753



JANUARY 18, 2024
 REVISED: MARCH 29, 2024

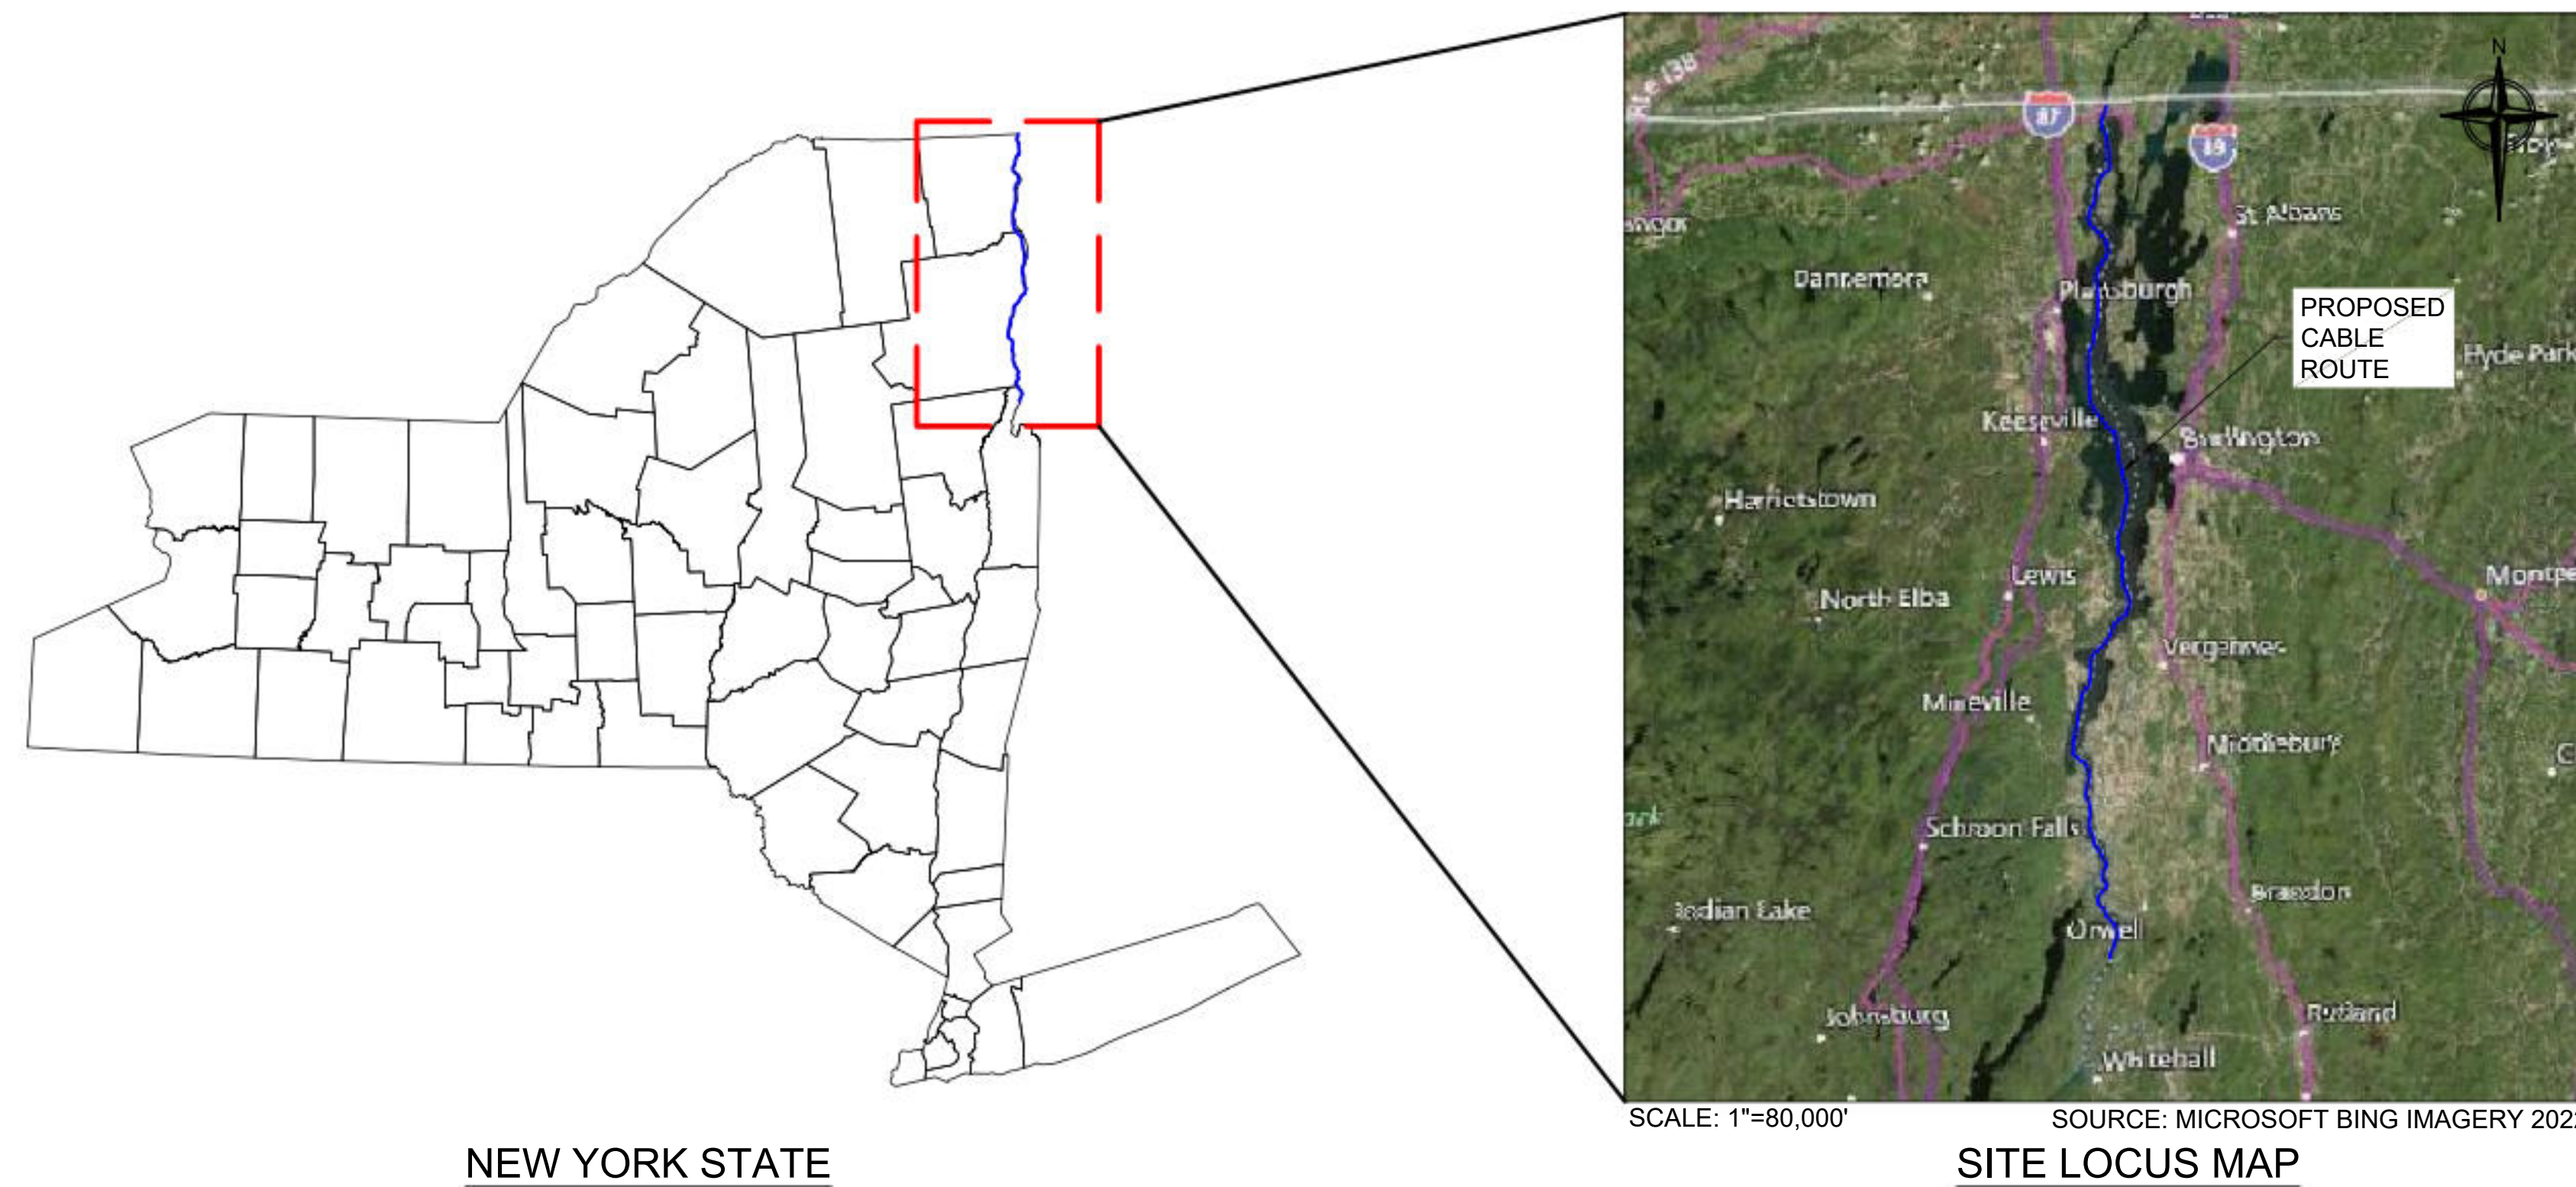

DRAWING INDEX


DRAWING NUMBER	SHEET NUMBER	SHEET TITLE
-	1	COVER SHEET
N-1	2	GENERAL NOTES
RPL-1	3	ROUTE POSITION LIST-2
RPL-2	4	ROUTE POSITION LIST-1
SO-1	5	SITE OVERVIEW
SO-2	6	CO-LOCATED INFRASTRUCTURE SUMMARY TABLE
C-1	7	PLAN & PROFILE STA 0+00.00 TO STA 126+64.00
C-2	8	PLAN & PROFILE STA 126+64.00 TO STA 253+28.00
C-3	9	PLAN & PROFILE STA 253+28.00 TO STA 379+92.00
C-4	10	PLAN & PROFILE STA 379+92.00 TO STA 506+56.00
C-5	11	PLAN & PROFILE STA 506+56.00 TO STA 633+20.00
C-6	12	PLAN & PROFILE STA 633+20.00 TO STA 759+84.00
C-7	13	PLAN & PROFILE STA 759+84.00 TO STA 886+48.00
C-8	14	PLAN & PROFILE STA 886+48.00 TO STA 1013+12.00
C-9	15	PLAN & PROFILE STA 1013+12.00 TO STA 1139+76.00
C-10	16	PLAN & PROFILE STA 1139+76.00 TO STA 1266+40.00
C-11	17	PLAN & PROFILE STA 1266+40.00 TO STA 1393+04.00
C-12	18	PLAN & PROFILE STA 1393+04.00 TO STA 1519+68.00
C-13	19	PLAN & PROFILE STA 1519+68.00 TO STA 1646+32.00
C-14	20	PLAN & PROFILE STA 1646+32.00 TO STA 1772+96.00
C-15	21	PLAN & PROFILE STA 1772+96.00 TO STA 1899+60.00
C-16	22	PLAN & PROFILE STA 1899+60.00 TO STA 2026+24.00
C-17	23	PLAN & PROFILE STA 2026+24.00 TO STA 2152+88.00
C-18	24	PLAN & PROFILE STA 2152+88.00 TO STA 2279+52.00
C-19	25	PLAN & PROFILE STA 2279+52.00 TO STA 2406+16.00
C-20	26	PLAN & PROFILE STA 2406+16.00 TO STA 2532+80.00
C-21	27	PLAN & PROFILE STA 2532+80.00 TO STA 2659+44.00
C-22	28	PLAN & PROFILE STA 2659+44.00 TO STA 2786+08.00
C-23	29	PLAN & PROFILE STA 2786+08.00 TO STA 2912+72.00
C-24	30	PLAN & PROFILE STA 2912+72.00 TO STA 3039+36.00
C-25	31	PLAN & PROFILE STA 3039+36.00 TO STA 3166+00.00
C-26	32	PLAN & PROFILE STA 3166+00.00 TO STA 3292+64.00
C-27	33	PLAN & PROFILE STA 3292+64.00 TO STA 3419+28.00
C-28	34	PLAN & PROFILE STA 3419+28.00 TO STA 3545+92.00
C-29	35	PLAN & PROFILE STA 3545+92.00 TO STA 3672+56.00
C-30	36	PLAN & PROFILE STA 3672+56.00 TO STA 3799+20.00
C-31	37	PLAN & PROFILE STA 3799+20.00 TO STA 3925+84.00
C-32	38	PLAN & PROFILE STA 3925+84.00 TO STA 4052+48.00
C-33	39	PLAN & PROFILE STA 4052+48.00 TO STA 4179+12.00
C-34	40	PLAN & PROFILE STA 4179+12.00 TO STA 4305+76.00
C-35	41	PLAN & PROFILE STA 4305+76.00 TO STA 4432+40.00
C-36	42	PLAN & PROFILE STA 4432+40.00 TO STA 4559+04.00
C-37	43	PLAN & PROFILE STA 4559+04.00 TO STA 4685+68.00
C-38	44	PLAN & PROFILE STA 4685+68.00 TO STA 4812+32.00
C-39	45	PLAN & PROFILE STA 4812+32.00 TO STA 4938+96.00
C-40	46	PLAN & PROFILE STA 4938+96.00 TO STA 5065+60.00
C-41	47	PLAN & PROFILE STA 5065+60.00 TO STA 5096+09.29

PREPARED BY:




FIRM REGISTRATION NO.:
 NY 0010187


OVERVIEW A

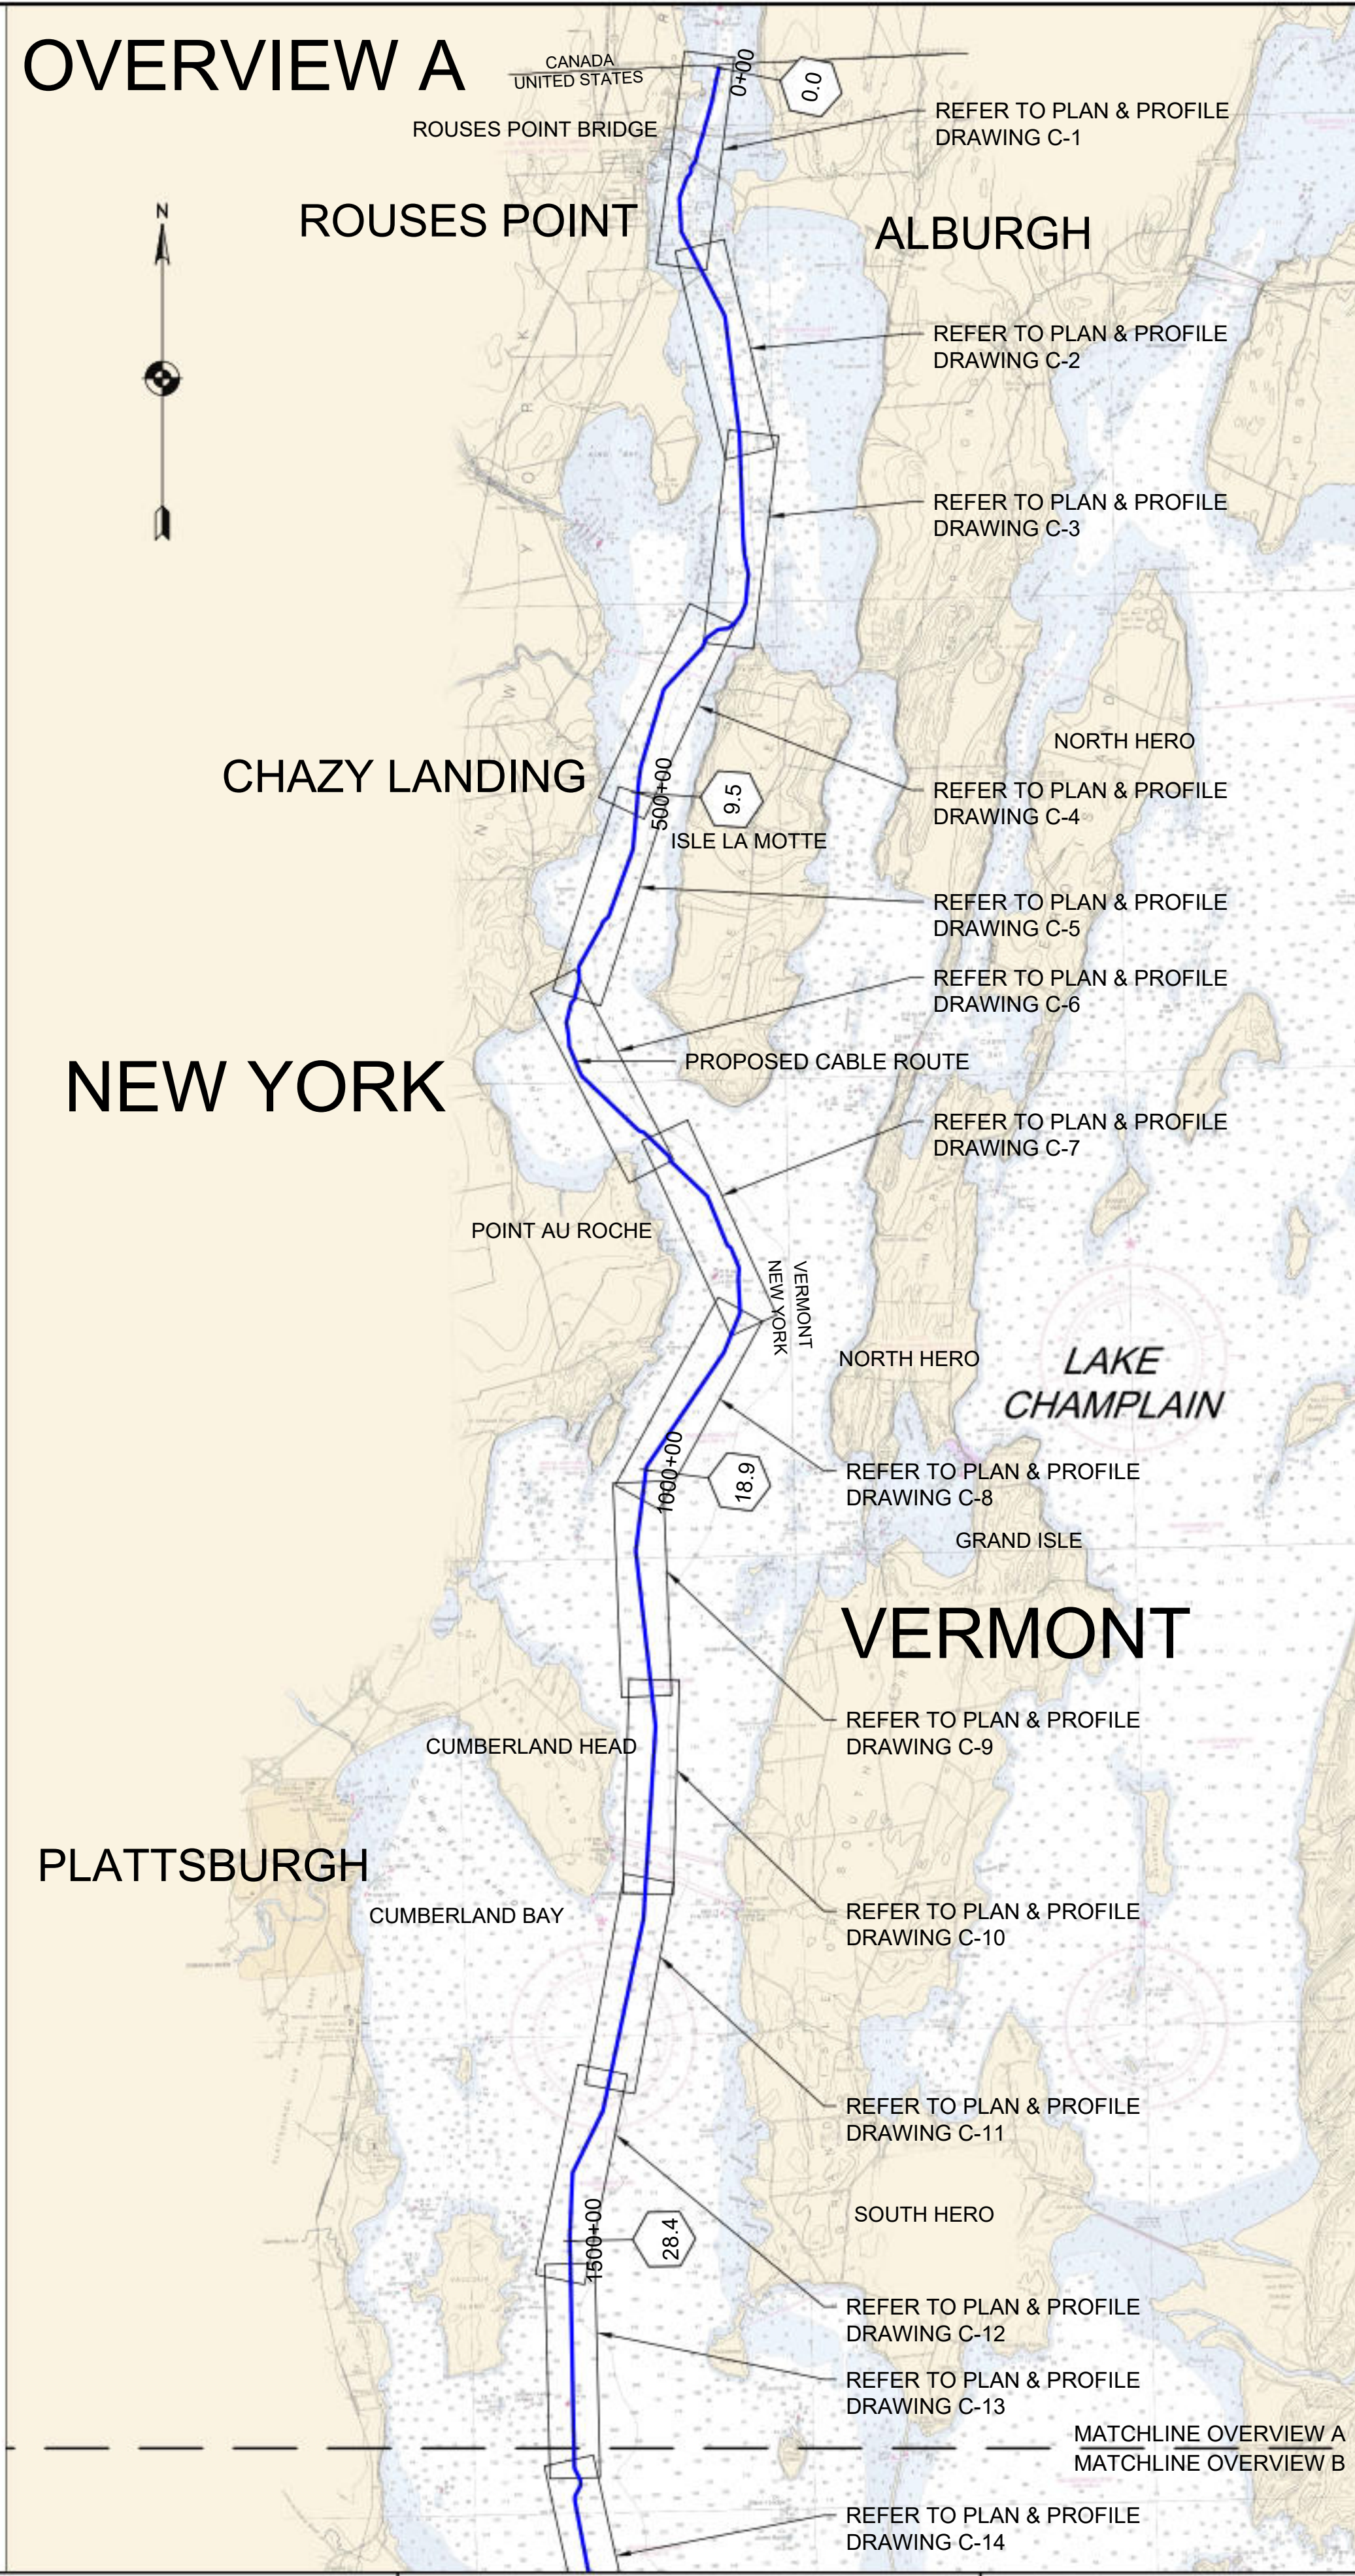

OVERVIEW B

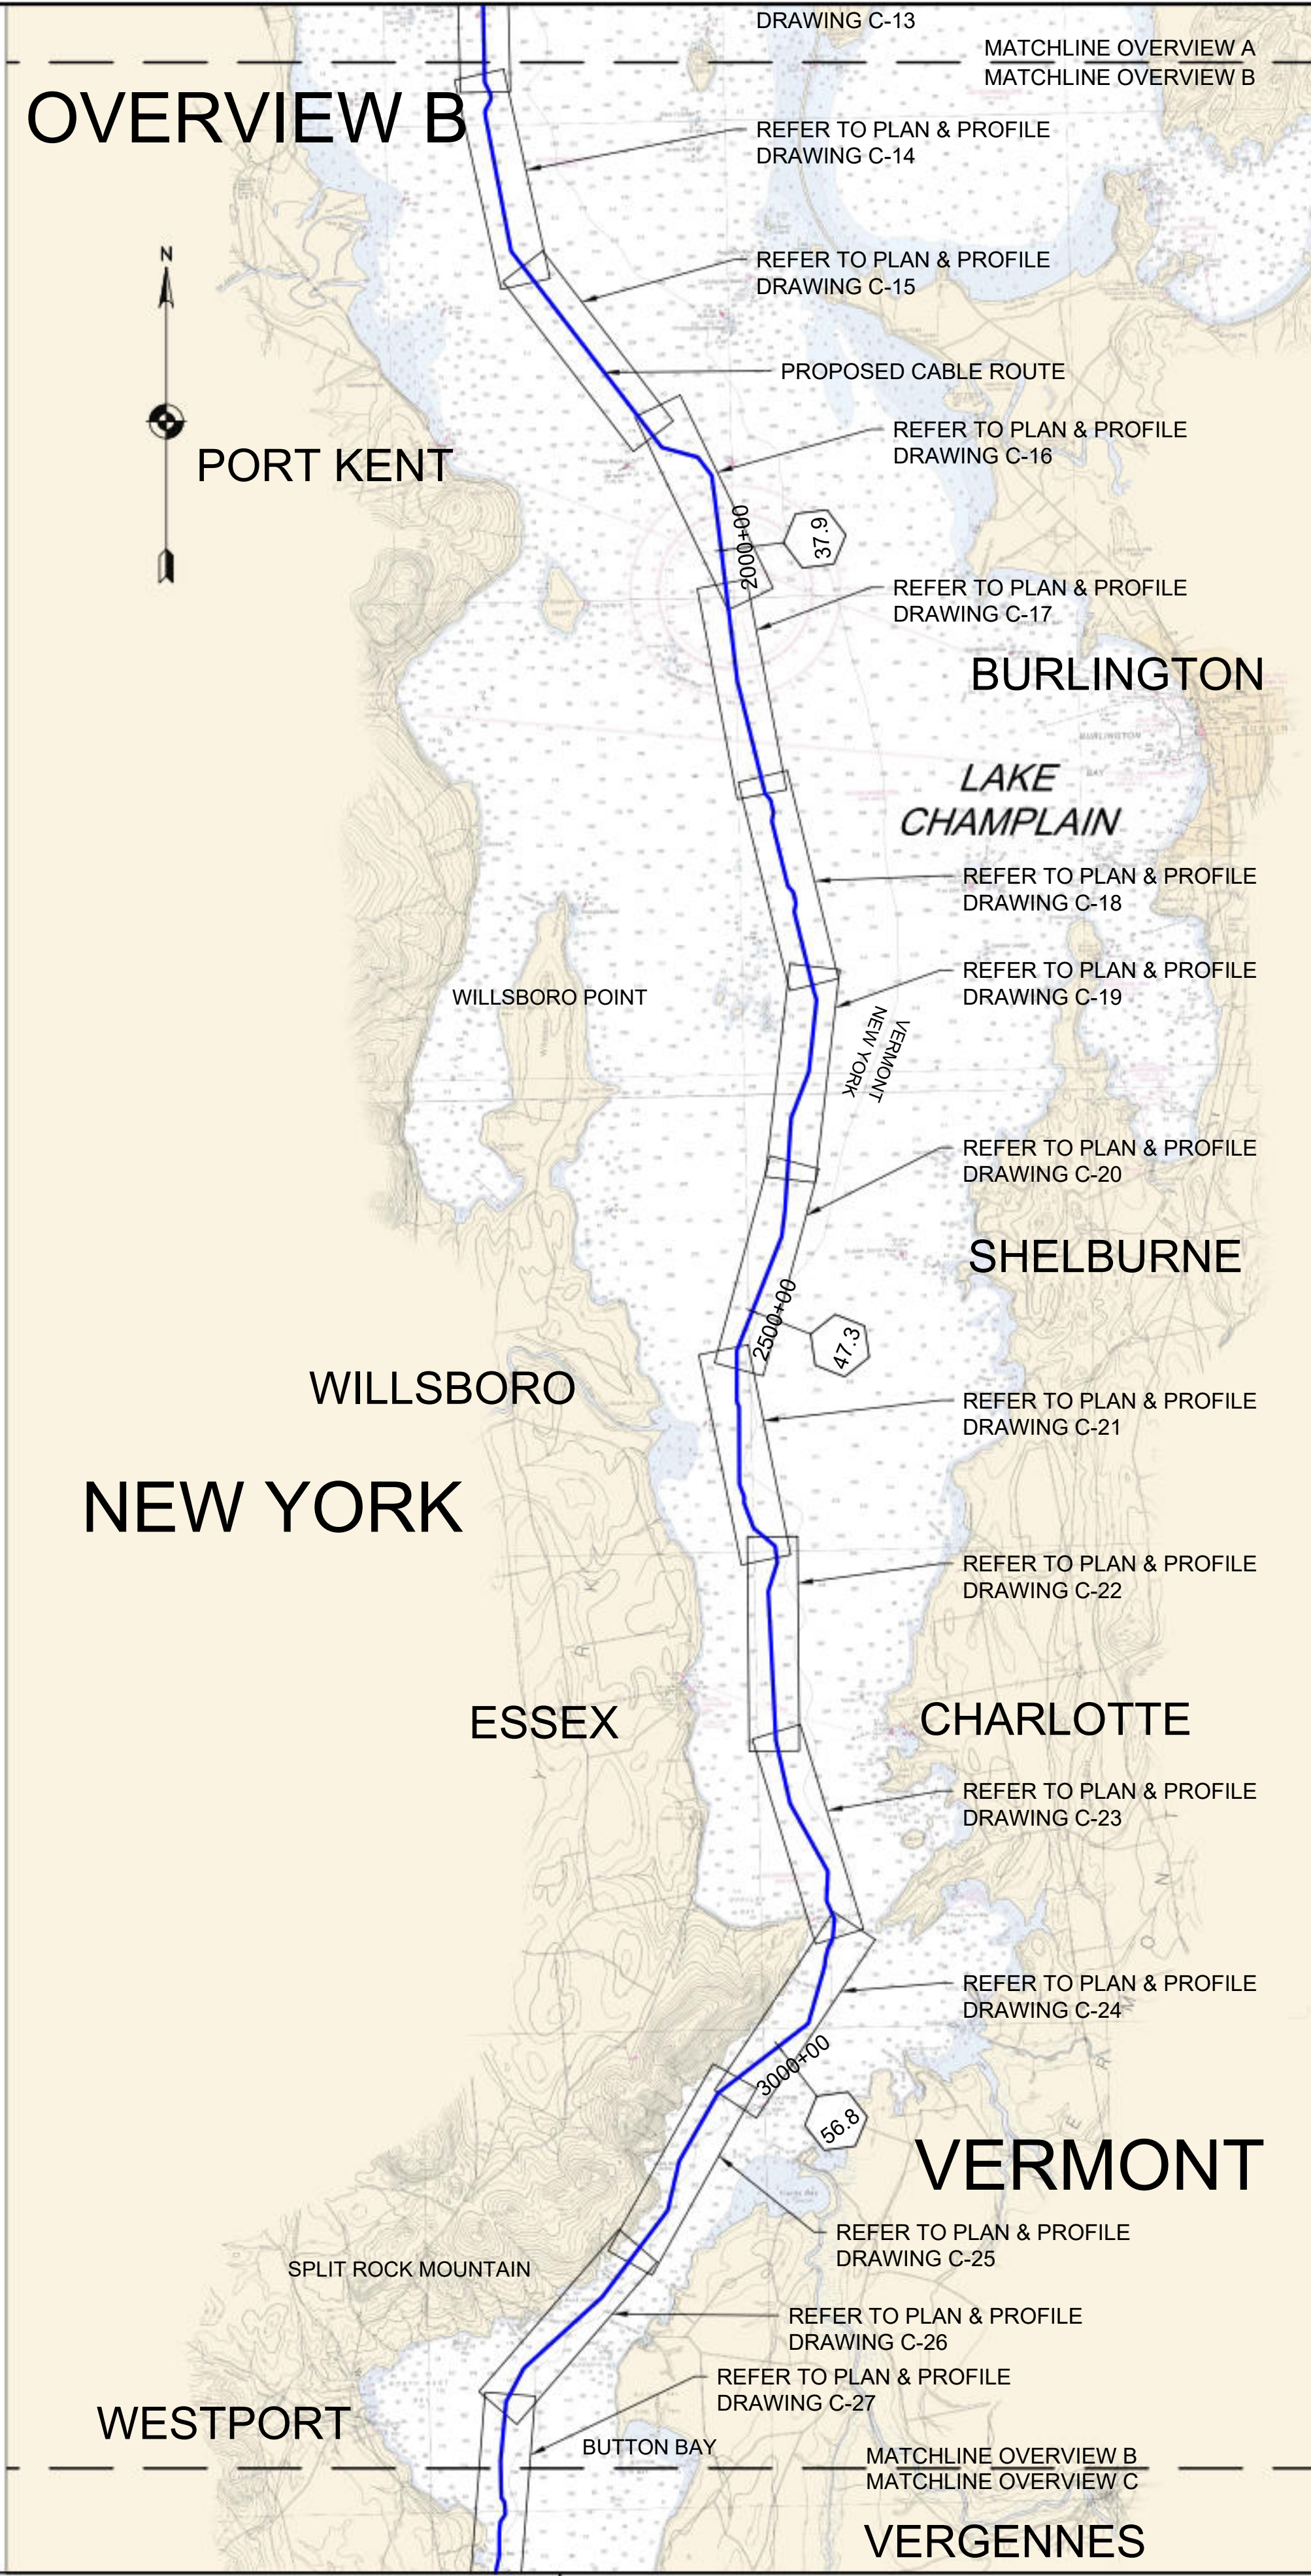

OVERVIEW C

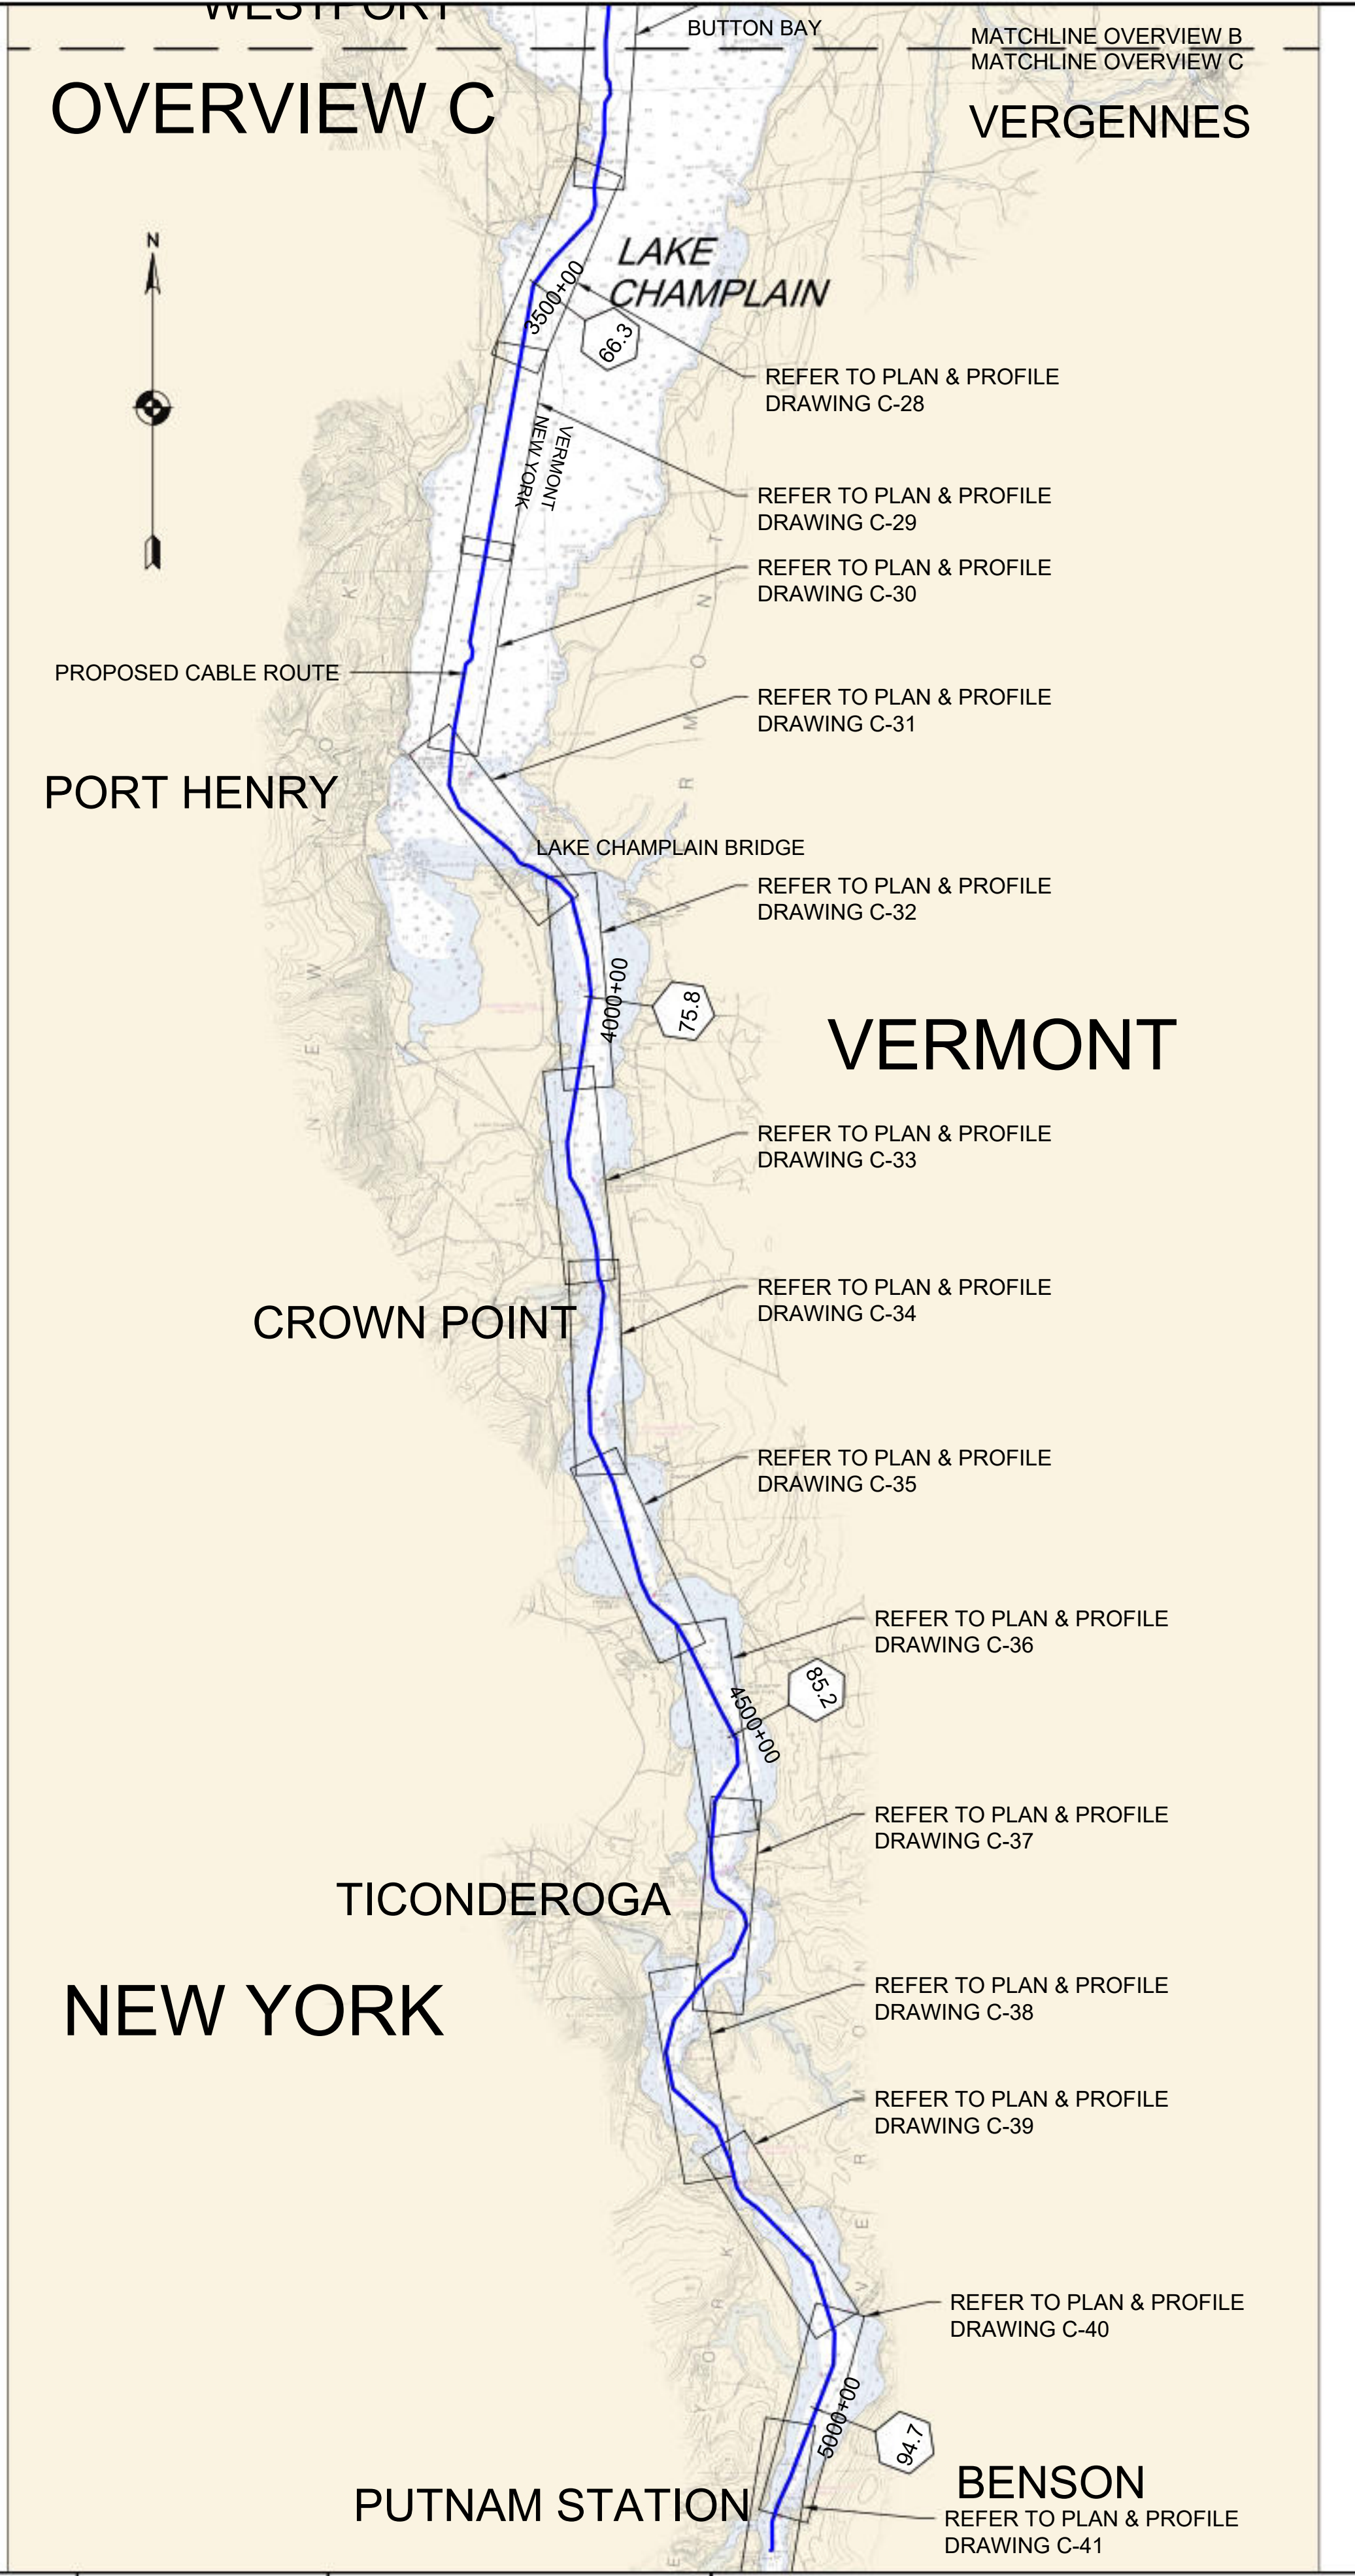

NOTES:

1. BASE PLAN OBTAINED FROM "CHAMPLAIN HUDSON POWER EXPRESS, LAKE CHAMPLAIN 2022 MARINE ROUTE SURVEY (MRS)" DATED DECEMBER 22, 2022. PROVIDED BY OCEAN SURVEY, INC.



Sharon L. Burke

REFERENCE DRAWINGS


DWG. NO.	TITLE

REVISIONS

NO.	DESCRIPTION	DATE	DRAWN	CHK	APPR

DRAWING APPROVALS

ROLE	NAME	DATE
DRAWN	LDC	01/05/24
CHECKED	GJR	01/17/24
ENGINEER	SB	01/18/24

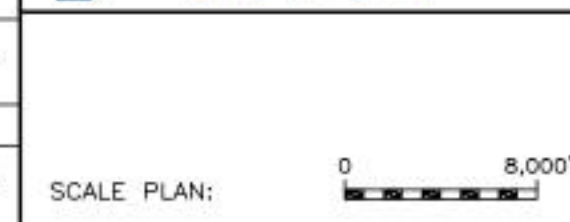

CHPE - LAKE CHAMPLAIN PROPOSED CABLE ROUTE EM&CP SEGMENT 18B SITE OVERVIEW

SCALE	PROJECT NO.	DRAWING NO.	SHT. NO.
NTS	532345	SO-1	5



Sharon L. Burke

REFERENCE DRAWINGS

DWG. NO.	TITLE

REVISIONS

NO.	DESCRIPTION	DATE	DRAWN	CHK	APPR


DRAWING APPROVALS

DRAWN	DATE
LDC	01/05/24
CHECKED	DATE
GJR	01/05/24
ENGINEER	DATE
SB	01/XX/24




**CHPE - LAKE CHAMPLAIN PROPOSED CABLE ROUTE
EM&CP SEGMENT 18B
CO-LOCATED INFRASTRUCTURE SUMMARY TABLE**

SCALE	PROJECT NO.	DRAWING NO.	SHT. NO.
NTS	532345	SO-2	6

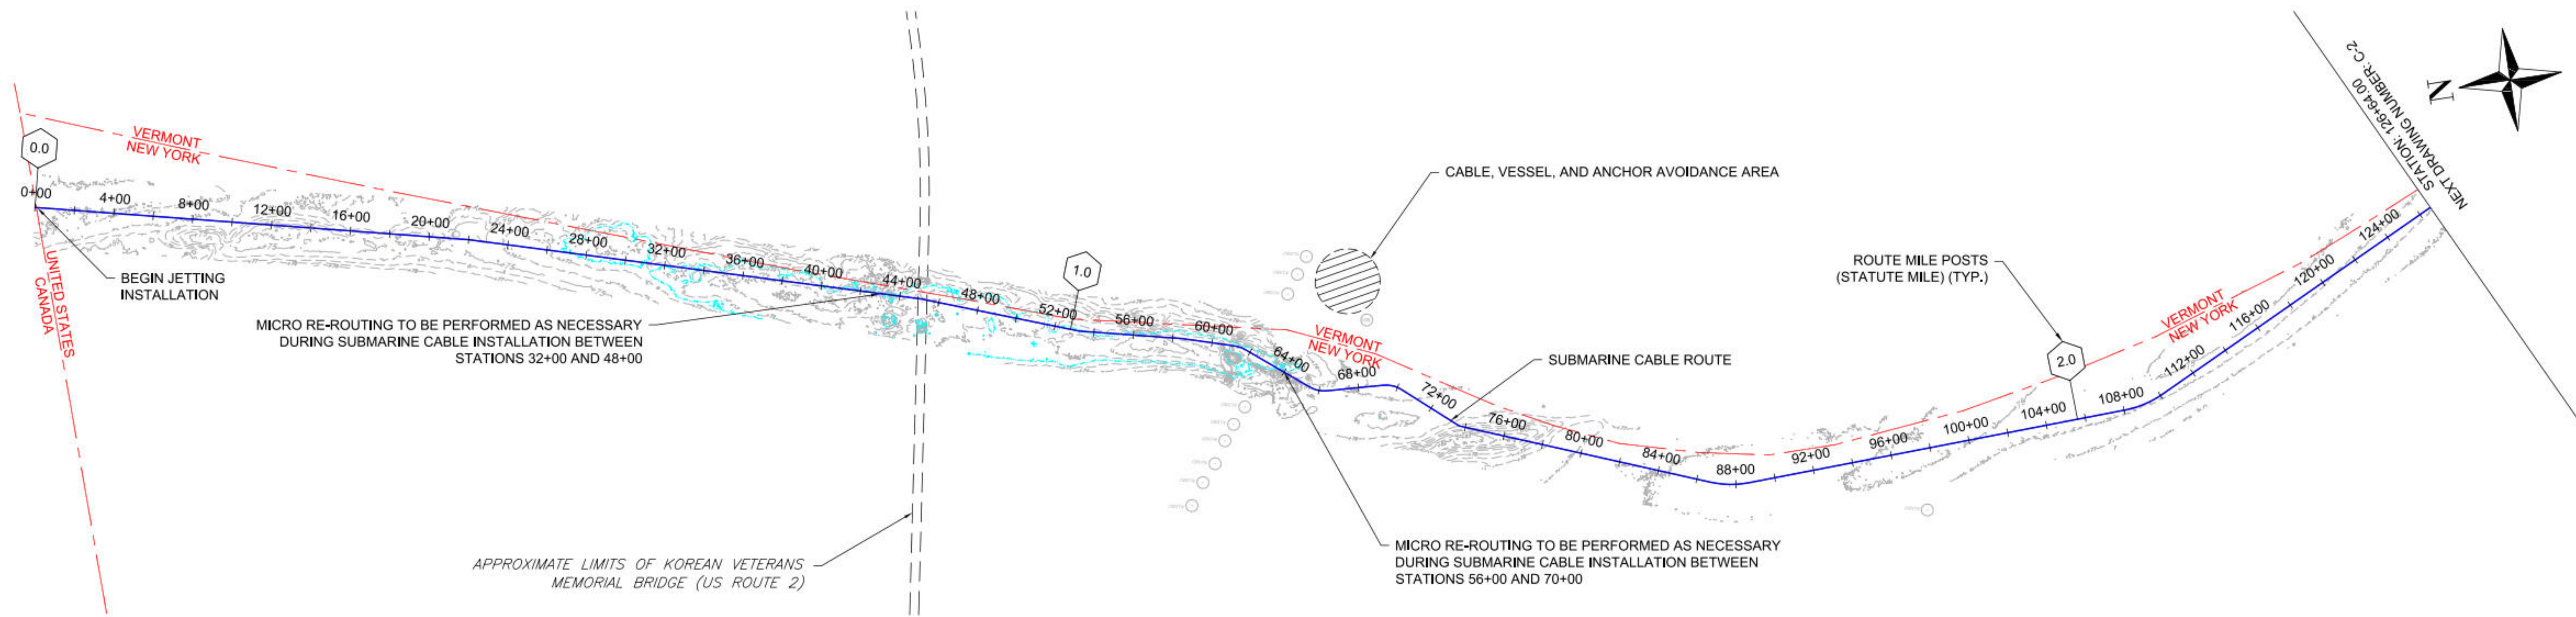

* PRE-LAY MATTRESS INSTALLATION APPROVED UNDER SEGMENT 18A EM&CP.

1 PLAN VIEW
SCALE: 1"=400'

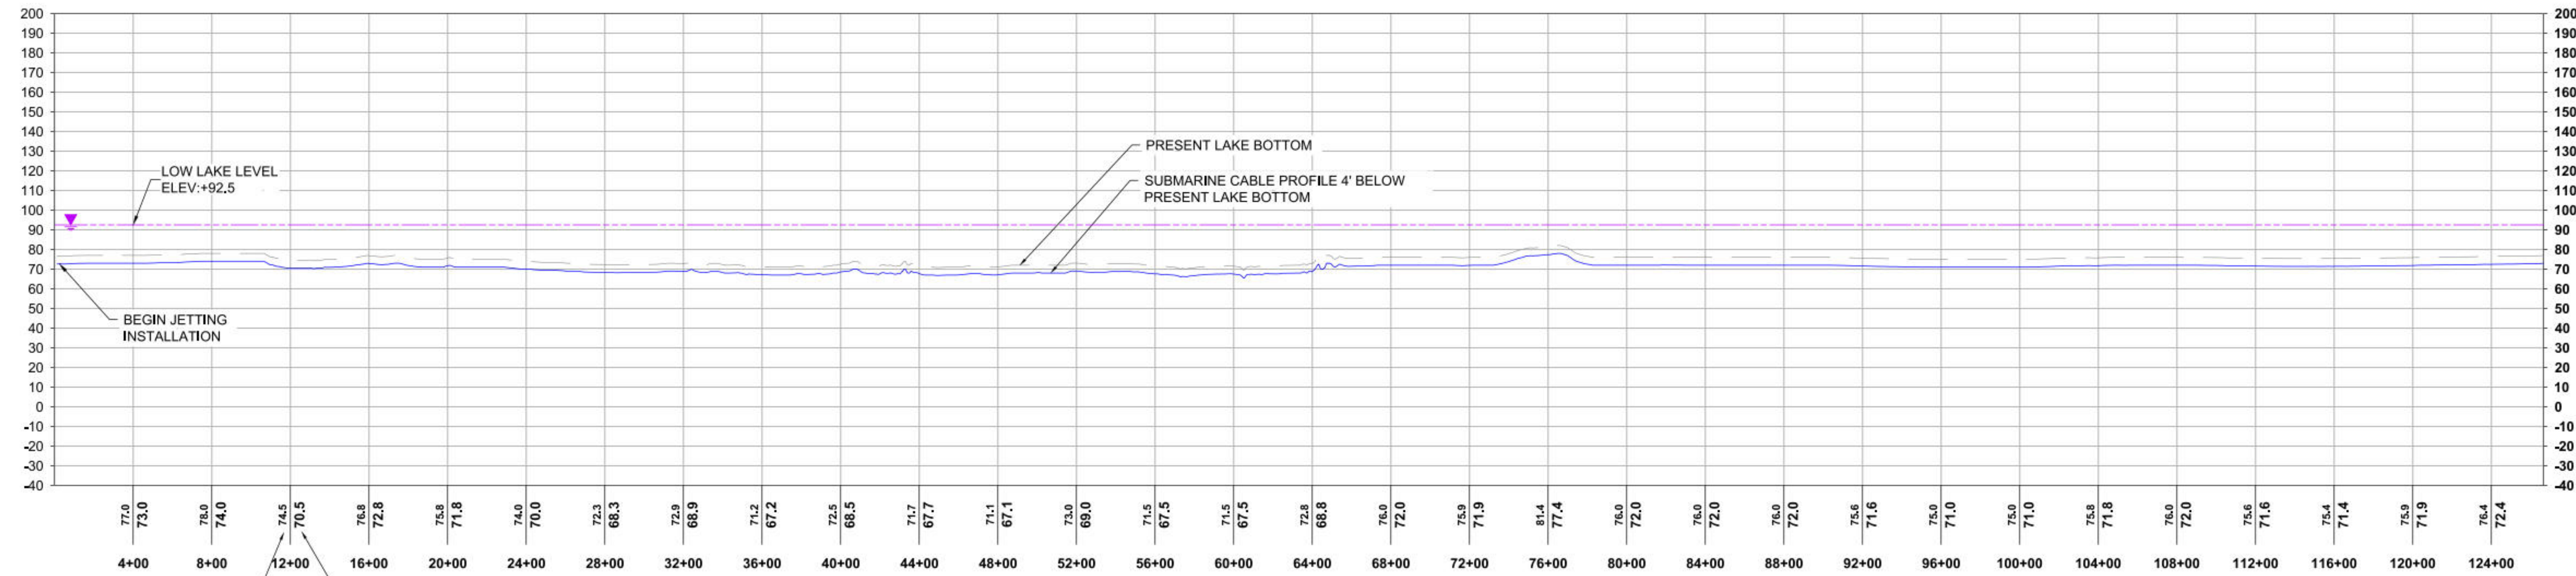

2 PROFILE VIEW
HORIZONTAL SCALE: 1"=400', VERTICAL SCALE: 1"=40'




REFERENCE DRAWINGS		REVISIONS					
DWG. NO.	TITLE	NO.	DESCRIPTION	DATE	DRAWN	CHK	APPR
		1	LLL ADDED PER NYS DPS REQUEST	03/29/2024	EYA	PRW	SB

DRAWING APPROVALS	
DRAWN	DATE
LDC	01/05/24
CHECKED	DATE
GJR	01/17/24
ENGINEER	DATE
SB	01/18/24


HORIZONTAL SCALE: 1"=400'

VERTICAL SCALE: 1"=40'

CHPE - LAKE CHAMPLAIN PROPOSED CABLE ROUTE EM&CP SEGMENT 18B PLAN & PROFILE STA 0+00.00 TO STA 126+64.00			
SCALE	PROJECT NO.	DRAWING NO.	SHT. NO.
1"=400'	532345	C-1	7

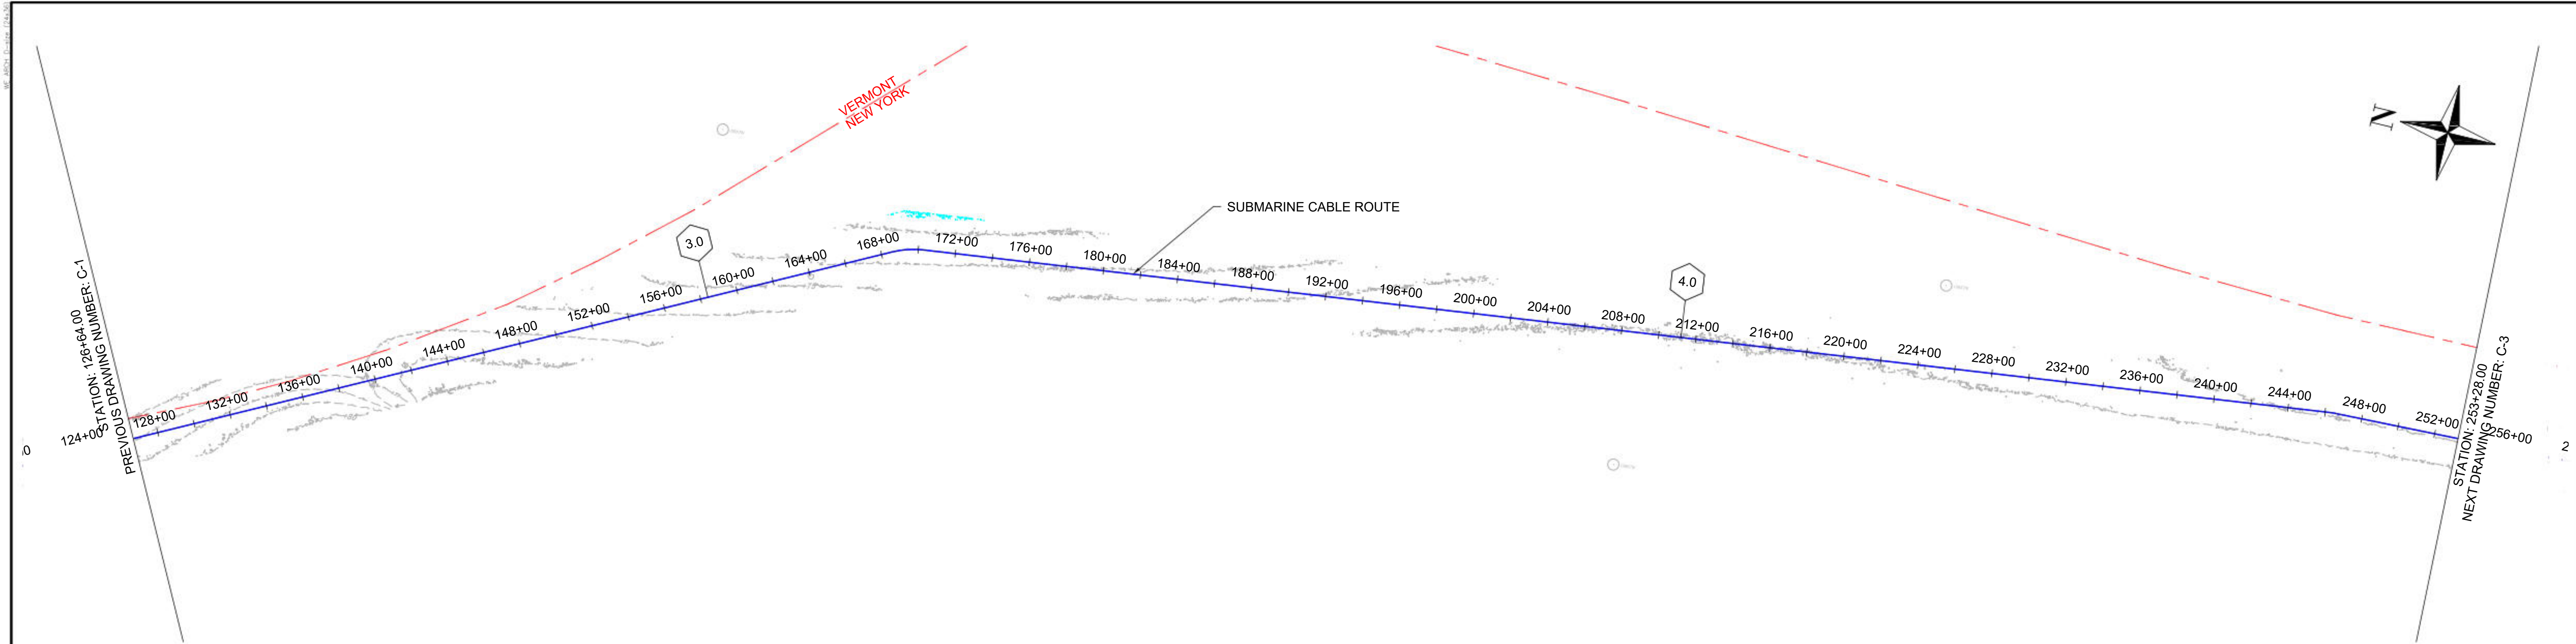

1 PLAN VIEW
SCALE: 1"=400'

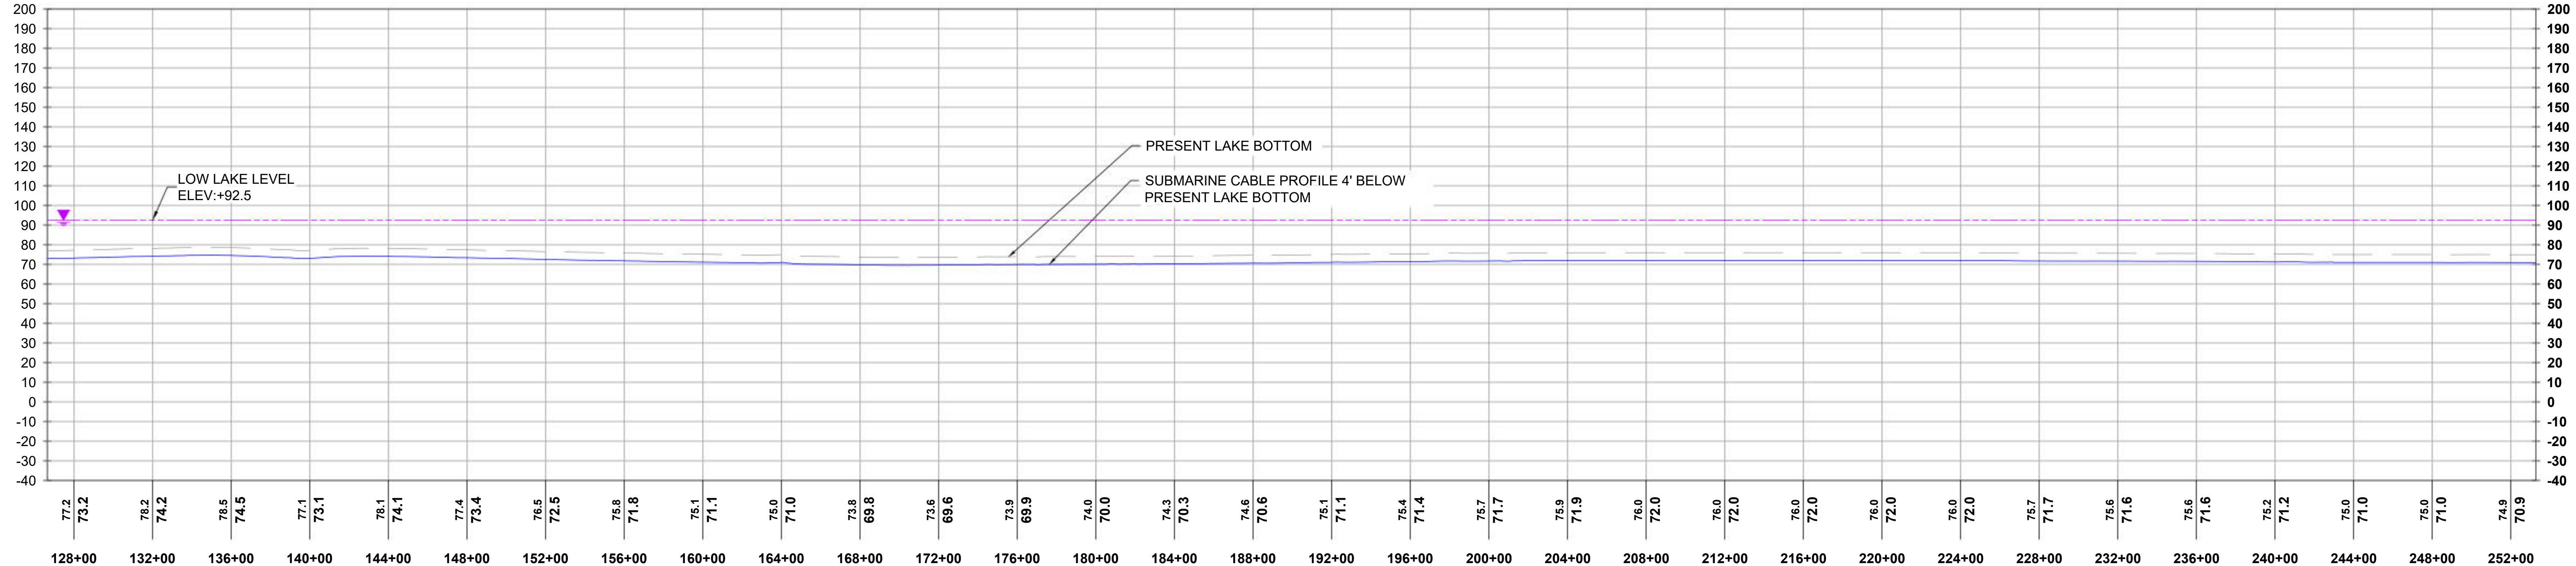

2 PROFILE VIEW
HORIZONTAL SCALE: 1"=400', VERTICAL SCALE: 1"=40'



REFERENCE DRAWINGS	
DWG. NO.	TITLE


REVISIONS					
NO.	DESCRIPTION	DATE	DRAWN	CHK	APPR
1	LLL ADDED PER NYS DPS REQUEST	03/29/2024	EYA	PRW	SB

DRAWING APPROVALS	
DRAWN	DATE
LDC	01/05/24
CHECKED	DATE
GJR	01/17/24
ENGINEER	DATE
SB	01/18/24


HORIZONTAL SCALE: 1"=400'

VERTICAL SCALE: 1"=40'

CHPE - LAKE CHAMPLAIN PROPOSED CABLE ROUTE EM&CP SEGMENT 18B PLAN & PROFILE STA 126+64.00 TO STA 253+28.00			
SCALE	PROJECT NO.	DRAWING NO.	SHT. NO.
1"=400'	532345	C-2	8

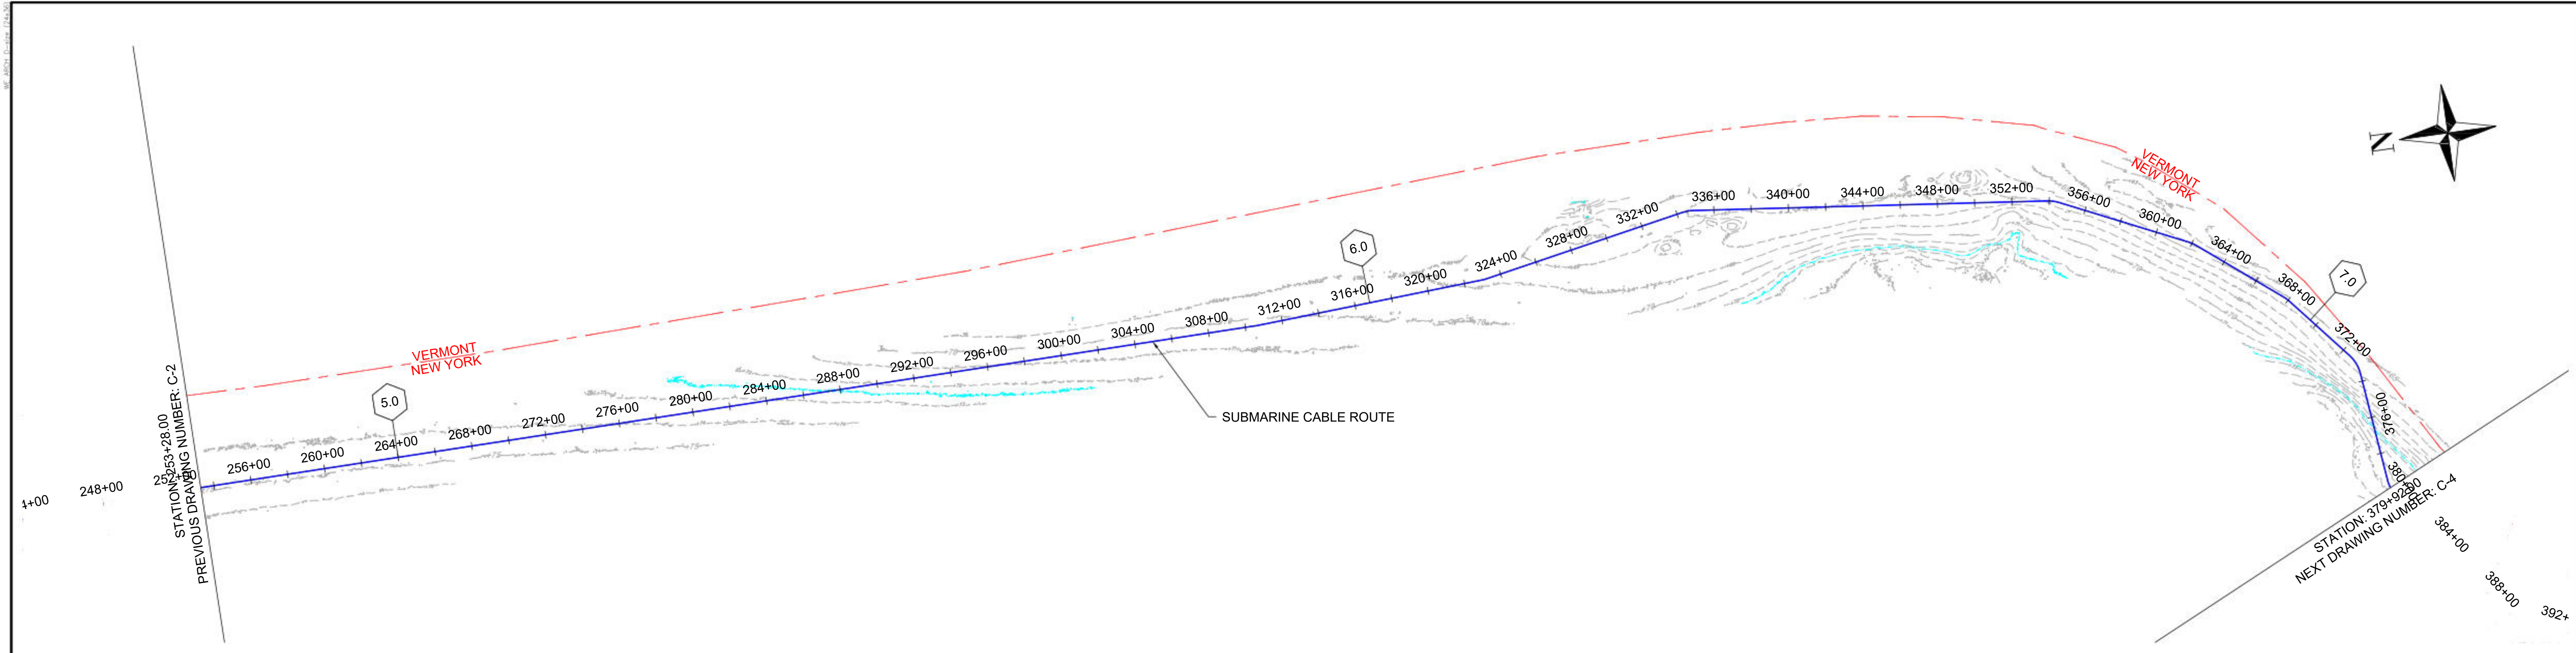


1 PLAN VIEW
SCALE: 1"=400'

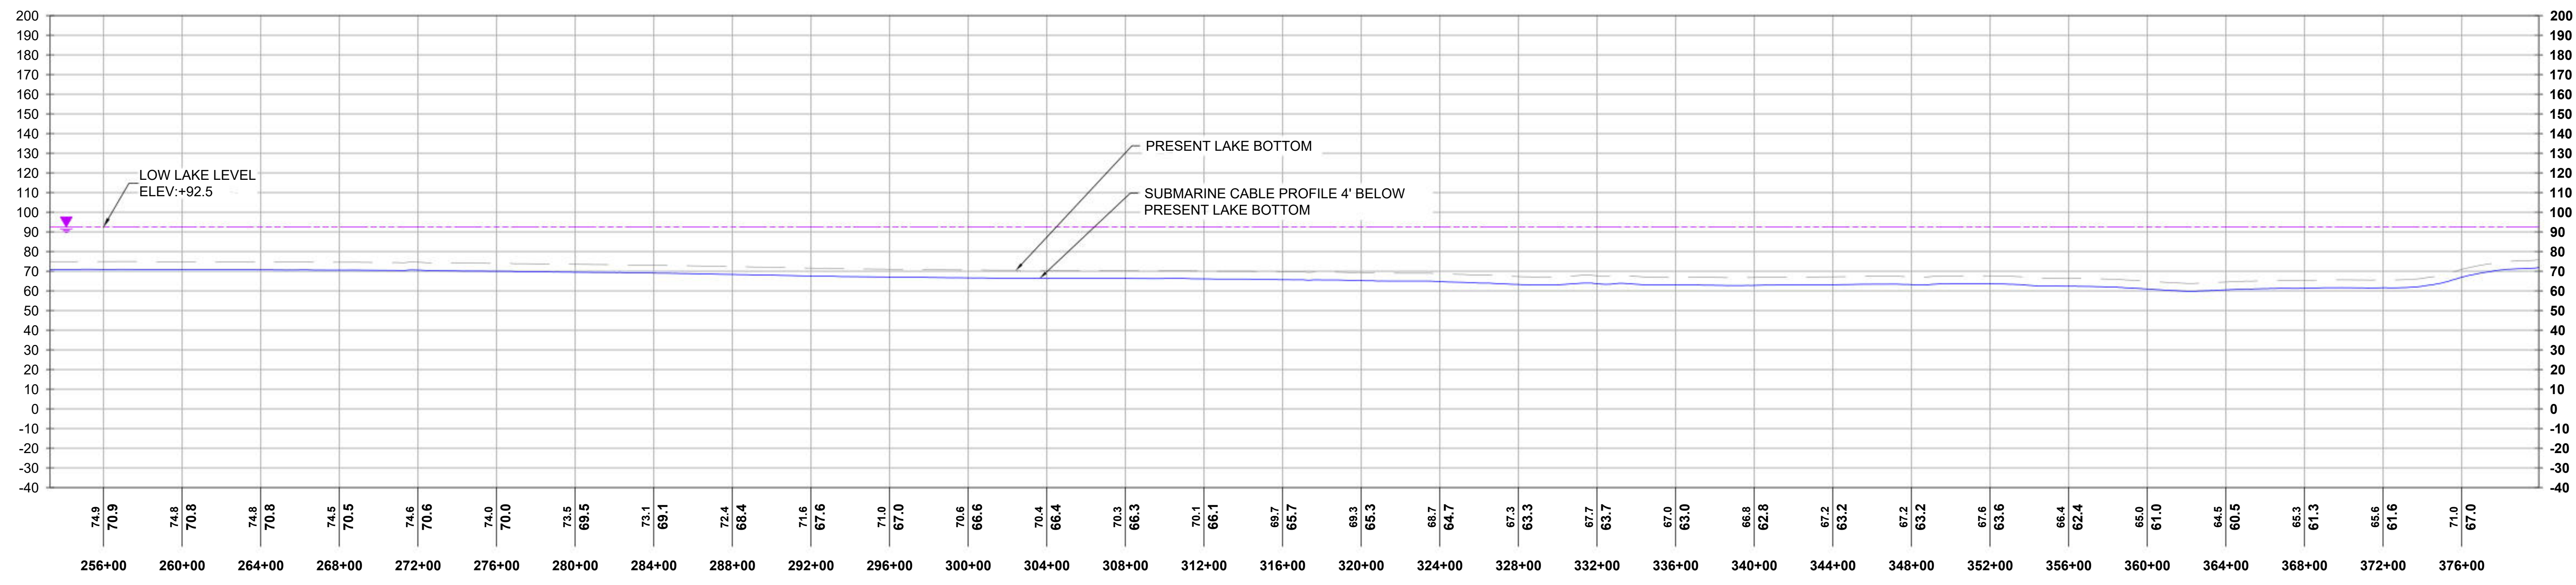


2 PROFILE VIEW
HORIZONTAL SCALE: 1"=400', VERTICAL SCALE: 1"=40'

		 Sharon L. Burke	REFERENCE DRAWINGS	REVISIONS	DRAWING APPROVALS	 HORIZONTAL SCALE: 1"=400' VERTICAL SCALE: 1"=40'	CHPE - LAKE CHAMPLAIN PROPOSED CABLE ROUTE EM&CP SEGMENT 18B PLAN & PROFILE STA 253+28.00 TO STA 379+92.00																																				
			<table border="1" style="width:100%; border-collapse: collapse;"> <thead> <tr> <th>DWG. NO.</th><th>TITLE</th><th>NO.</th><th>DESCRIPTION</th><th>DATE</th><th>DRAWN</th><th>CHK</th><th>APPR</th></tr> </thead> <tbody> <tr> <td>1</td><td>LLL ADDED PER NYS DPS REQUEST</td><td></td><td></td><td>03/29/2024</td><td>EYA</td><td>PRW</td><td>SB</td></tr> </tbody> </table>	DWG. NO.	TITLE			NO.	DESCRIPTION	DATE	DRAWN	CHK	APPR	1	LLL ADDED PER NYS DPS REQUEST			03/29/2024	EYA	PRW	SB	<table border="1" style="width:100%; border-collapse: collapse;"> <thead> <tr> <th>DRAWN</th><th>DATE</th><th>CHECKED</th><th>DATE</th><th>ENGINEER</th><th>DATE</th></tr> </thead> <tbody> <tr> <td>LDC</td><td>01/05/24</td><td>GJR</td><td>01/17/24</td><td>SB</td><td>01/18/24</td></tr> </tbody> </table>	DRAWN	DATE	CHECKED	DATE	ENGINEER	DATE	LDC	01/05/24	GJR	01/17/24	SB	01/18/24	<table border="1" style="width:100%; border-collapse: collapse;"> <thead> <tr> <th>SCALE</th><th>PROJECT NO.</th><th>DRAWING NO.</th><th>SHT. NO.</th></tr> </thead> <tbody> <tr> <td>1"=400'</td><td>532345</td><td>C-3</td><td>9</td></tr> </tbody> </table>	SCALE	PROJECT NO.	DRAWING NO.	SHT. NO.	1"=400'	532345	C-3	9
			DWG. NO.	TITLE	NO.			DESCRIPTION	DATE	DRAWN	CHK	APPR																															
1	LLL ADDED PER NYS DPS REQUEST			03/29/2024	EYA	PRW	SB																																				
DRAWN	DATE	CHECKED	DATE	ENGINEER	DATE																																						
LDC	01/05/24	GJR	01/17/24	SB	01/18/24																																						
SCALE	PROJECT NO.	DRAWING NO.	SHT. NO.																																								
1"=400'	532345	C-3	9																																								

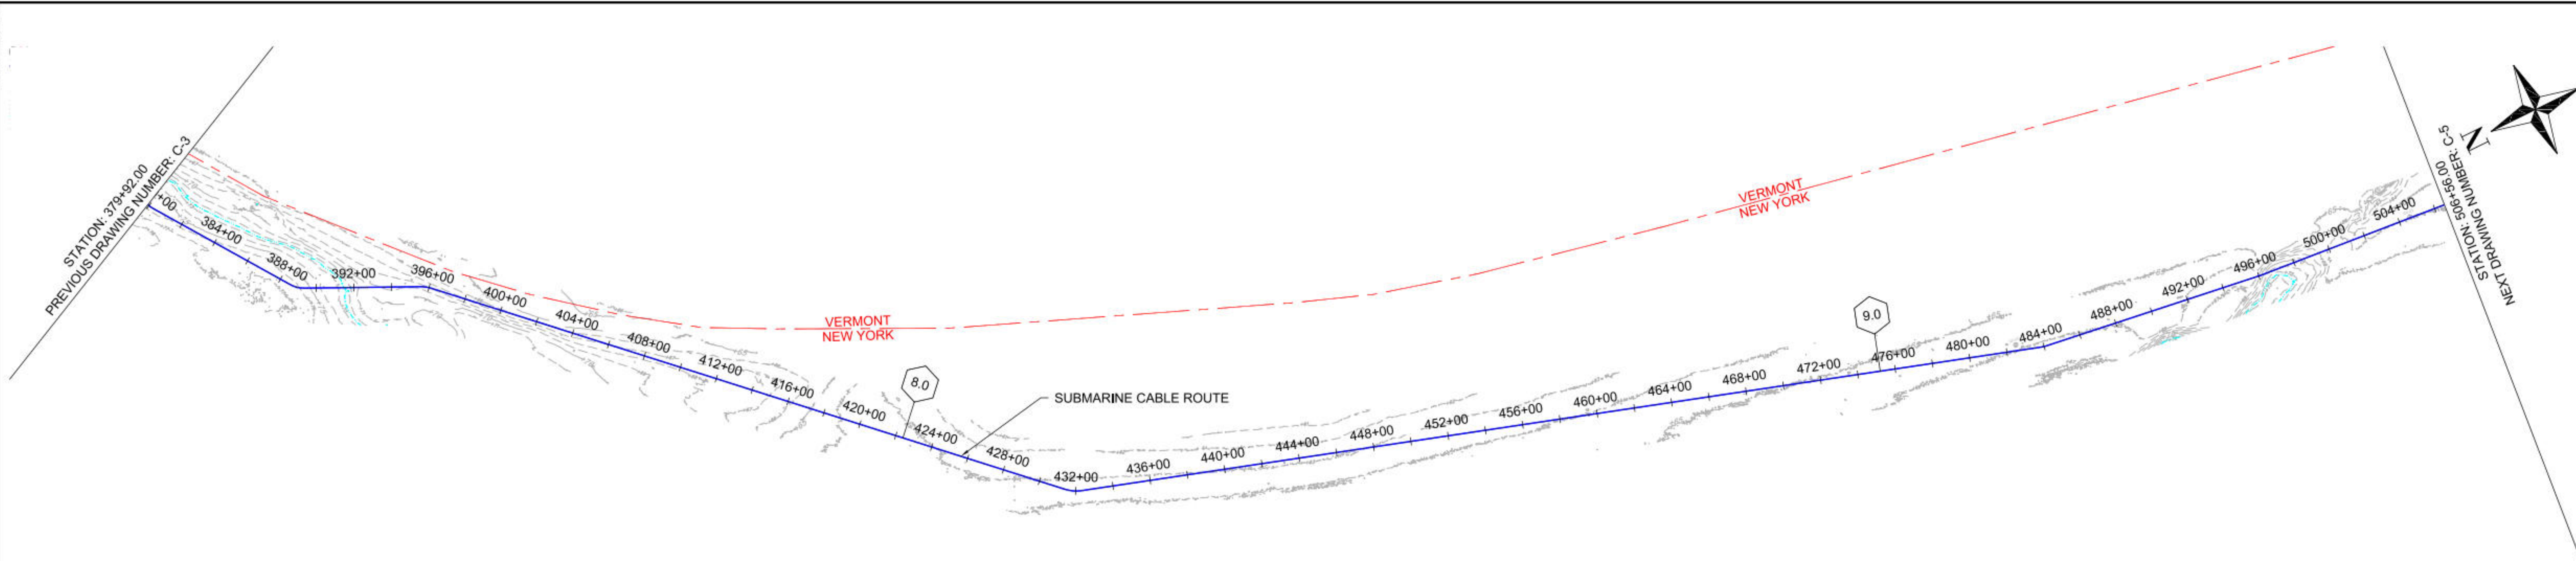

* PRE-LAY MATTRESS INSTALLATION APPROVED UNDER SEGMENT 18A EM&CP.

1 PLAN VIEW
SCALE: 1"=400'

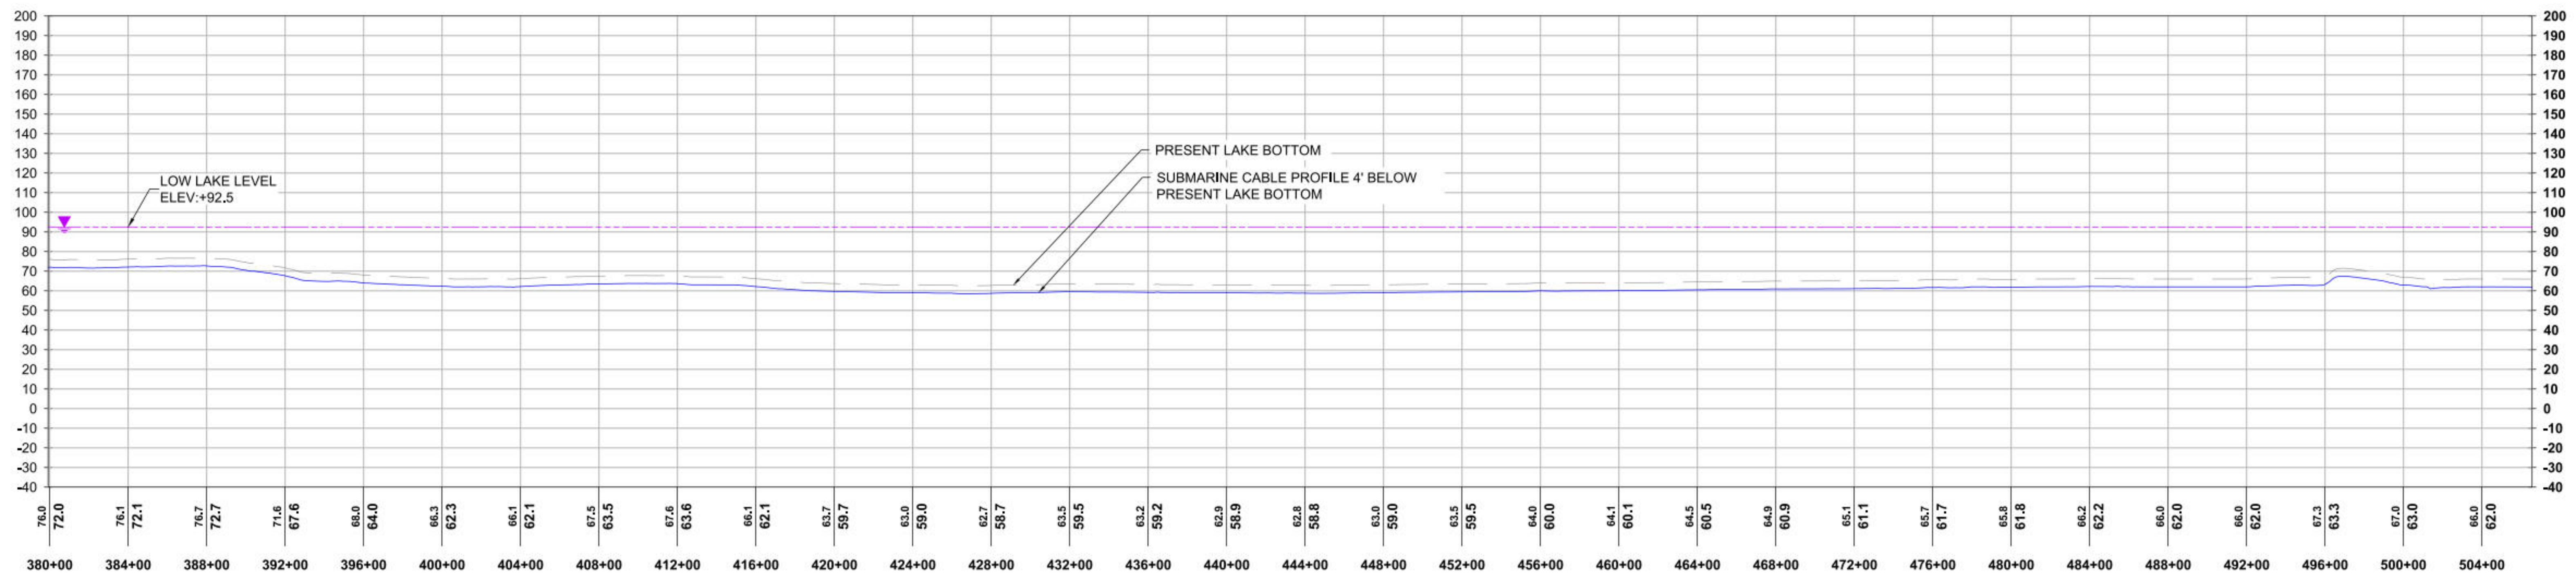

2 PROFILE VIEW
HORIZONTAL SCALE: 1"=400', VERTICAL SCALE: 1"=40'



Sharon L. Burke

REFERENCE DRAWINGS


DWG. NO.	TITLE

REVISIONS

NO.	DESCRIPTION	DATE	DRAWN	CHK	APPR
1	LLL ADDED PER NYS DPS REQUEST	03/29/2024	EYA	PRW	SB


DRAWING APPROVALS

DRAWN	DATE
LDC	01/05/24
CHECKED	DATE
GJR	01/17/24
ENGINEER	DATE
SB	01/18/24

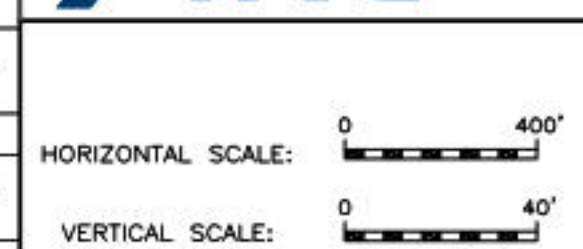


CHPE - LAKE CHAMPLAIN PROPOSED CABLE ROUTE
EM&CP SEGMENT 18B
PLAN & PROFILE STA 379+92.00 TO STA 506+56.00

SCALE	PROJECT NO.	DRAWING NO.	SHT. NO.
1"=400'	532345	C-4	10

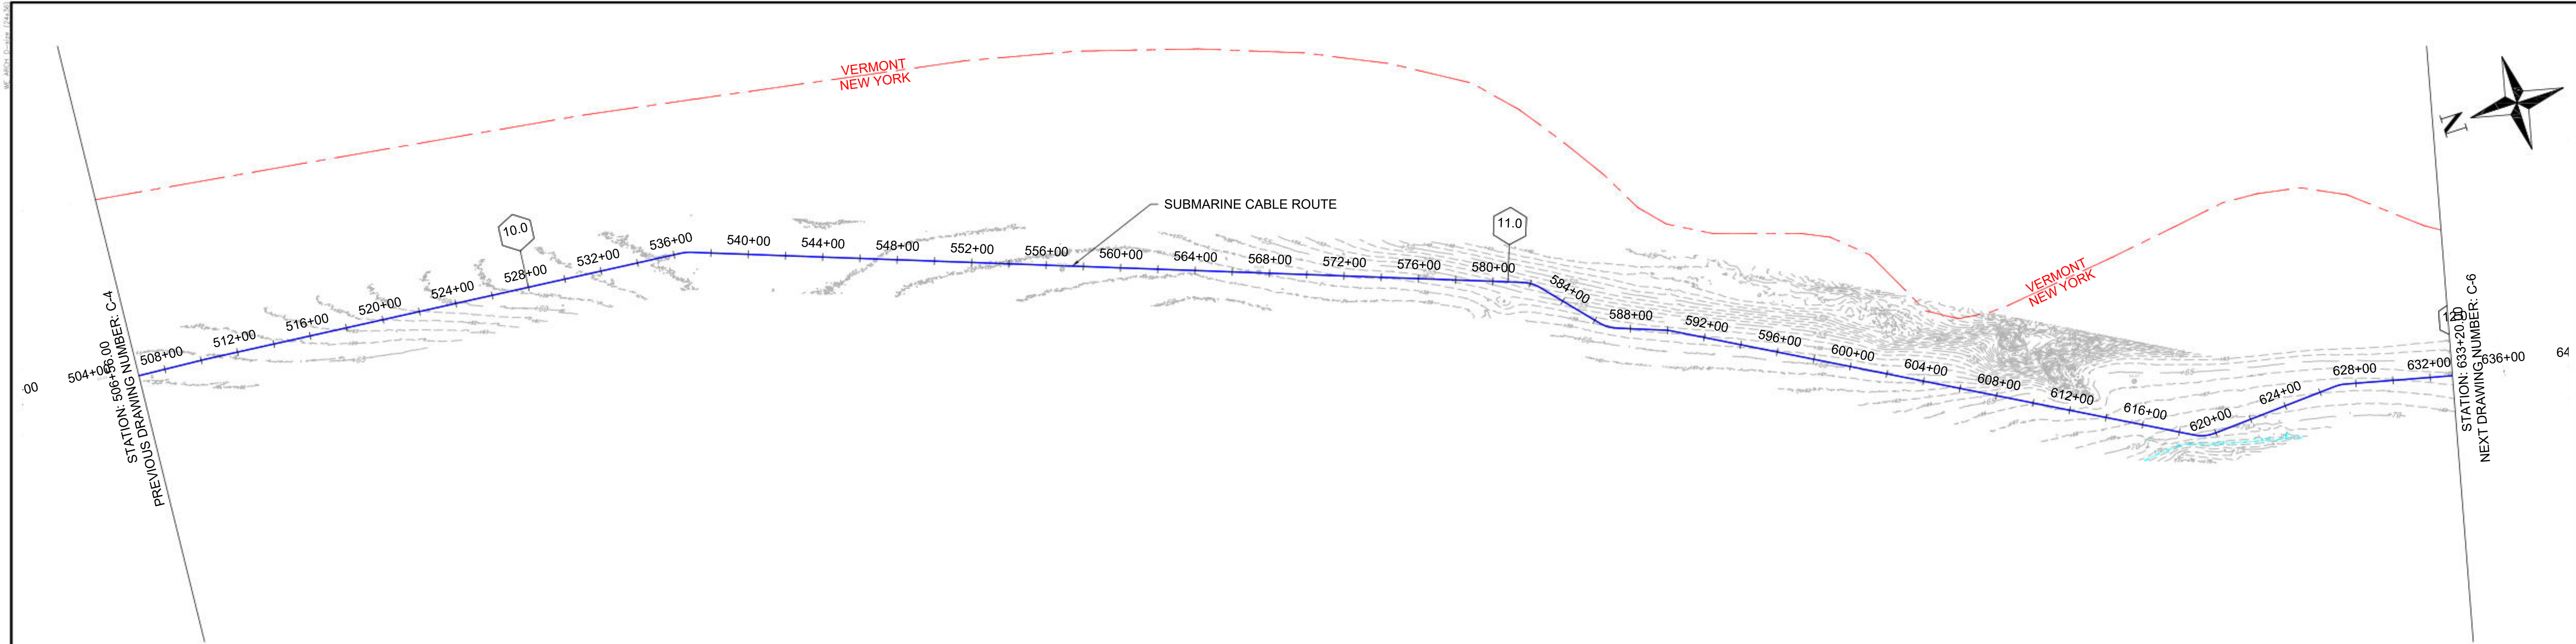


1 PLAN VIEW
SCALE: 1"=400'

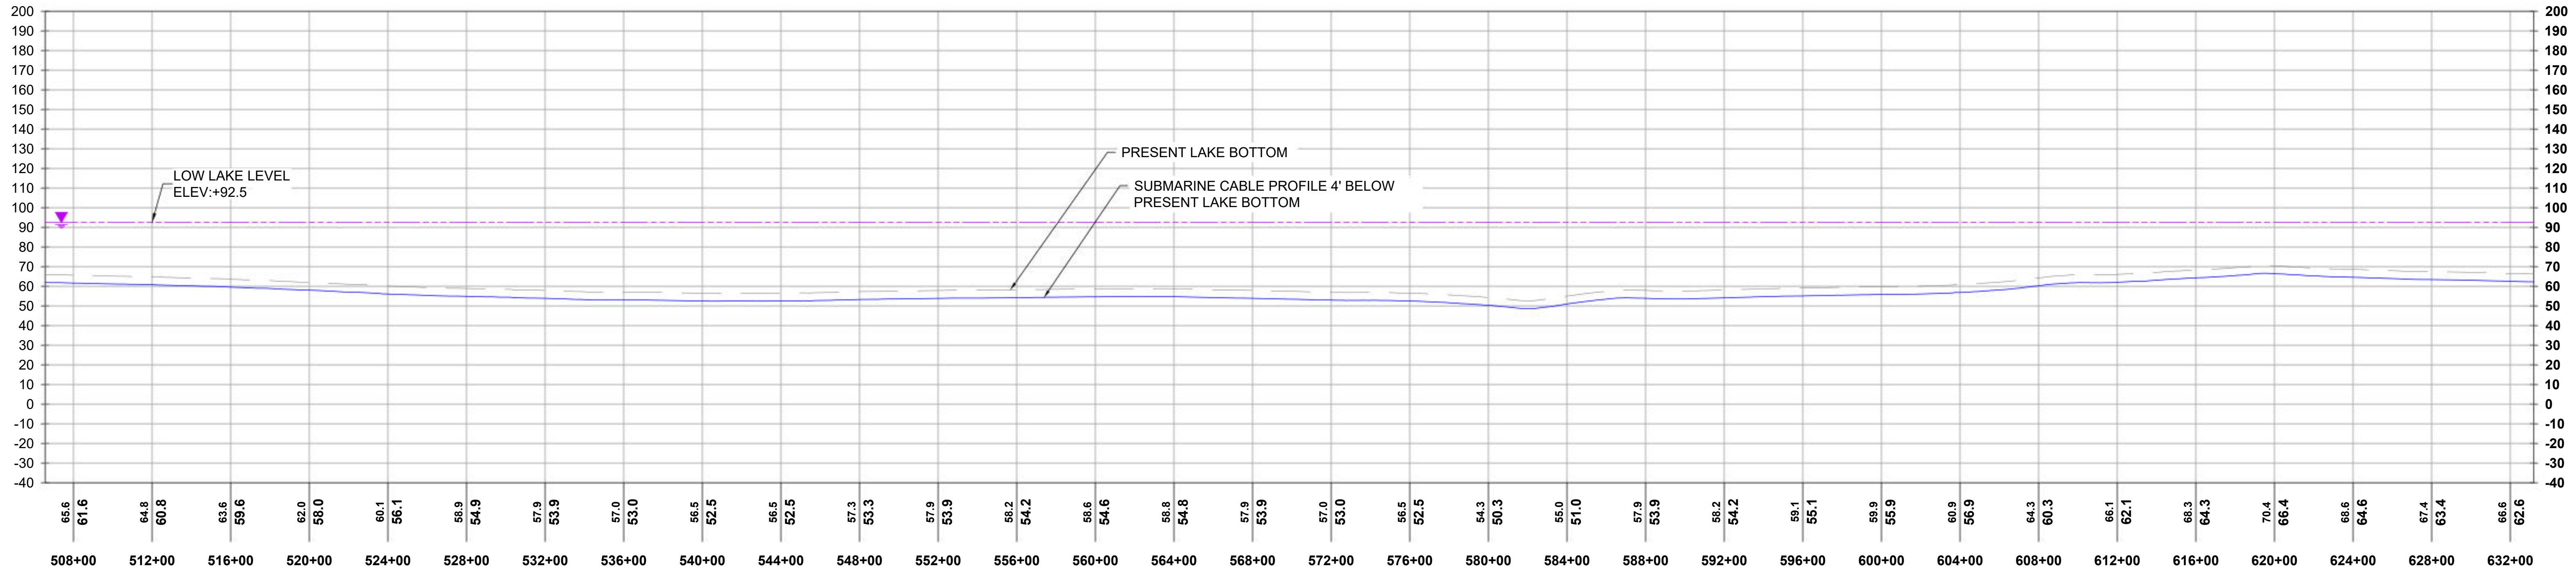


2 PROFILE VIEW
HORIZONTAL SCALE: 1"=400', VERTICAL SCALE: 1"=40'

<p>Steven L. Burke</p>	REFERENCE DRAWINGS		REVISIONS					DRAWING APPROVALS		<p>HORIZONTAL SCALE: 1"=400' VERTICAL SCALE: 1"=40'</p>	CHPE - LAKE CHAMPLAIN PROPOSED CABLE ROUTE EM&CP SEGMENT 18B PLAN & PROFILE STA 506+56.00 TO STA 633+20.00				
	DWG. NO.	TITLE	NO.	DESCRIPTION	DATE	DRAWN	CHK	APPR	DRAWN			DATE			
			1	LLL ADDED PER NYS DPS REQUEST	03/29/2024	EYA	PRW	SB	LDC			01/05/24			
									GJR			01/17/24			
								ENGINEER	DATE	SB	01/18/24	SCALE	PROJECT NO.	DRAWING NO.	SHT. NO.
												1"=400'	532345	C-5	11

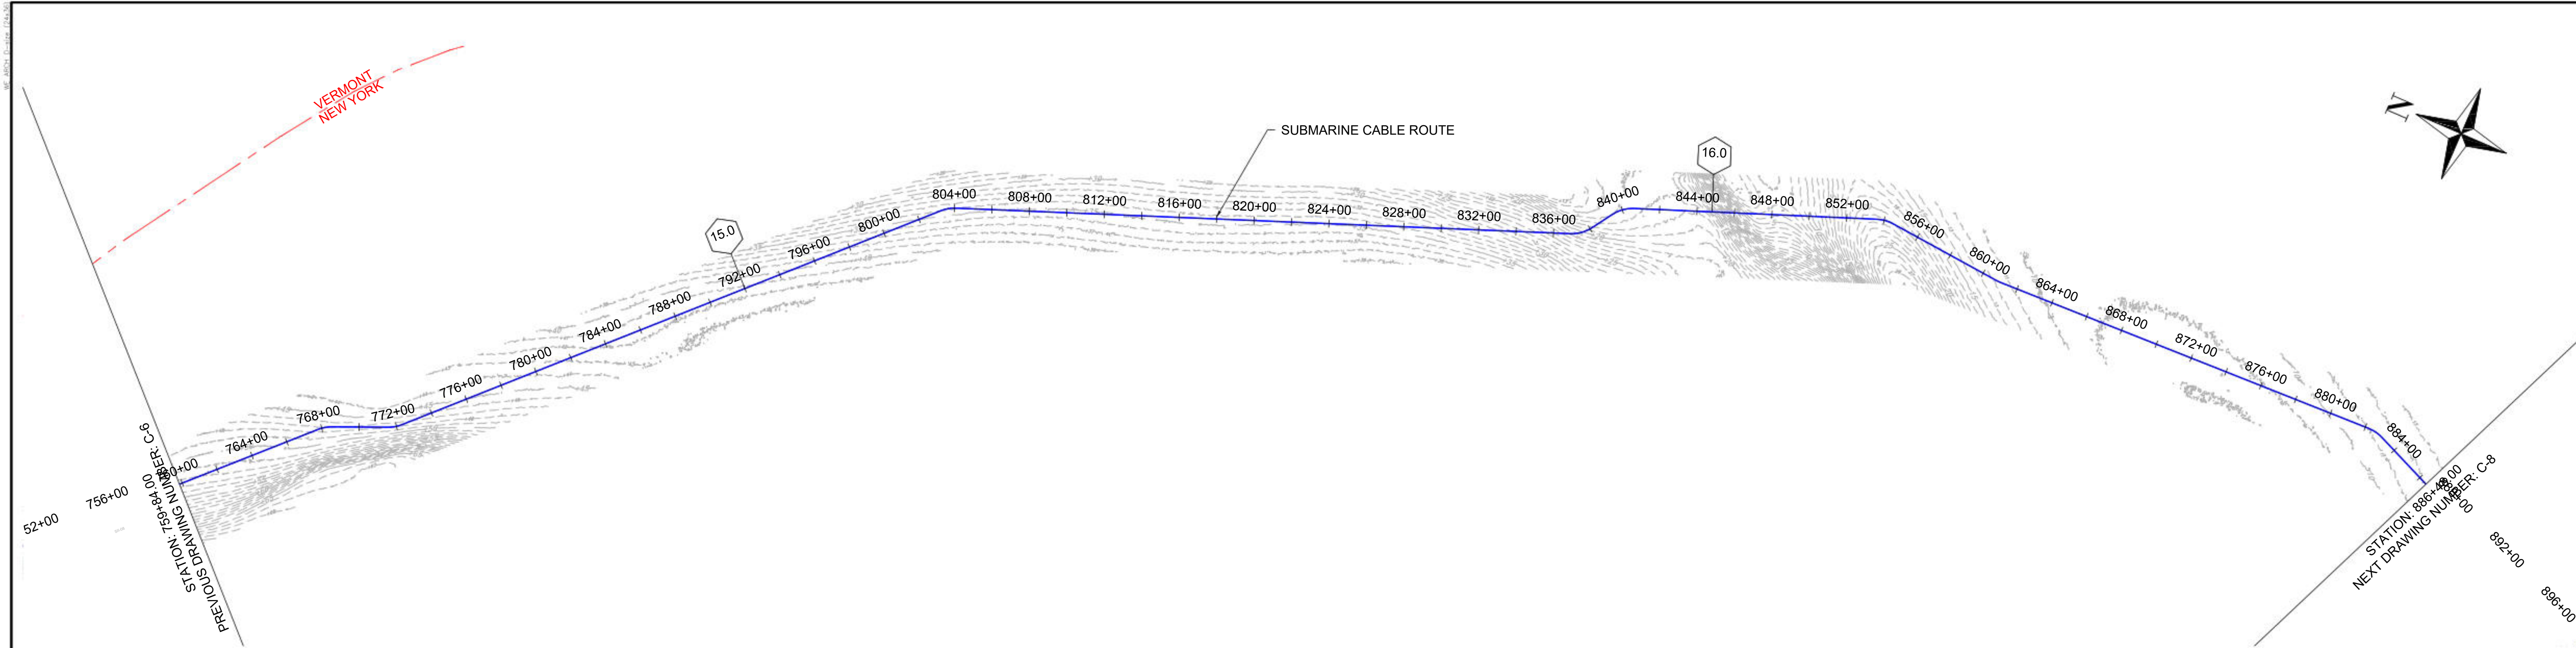

1 PLAN VIEW
SCALE: 1"=400'

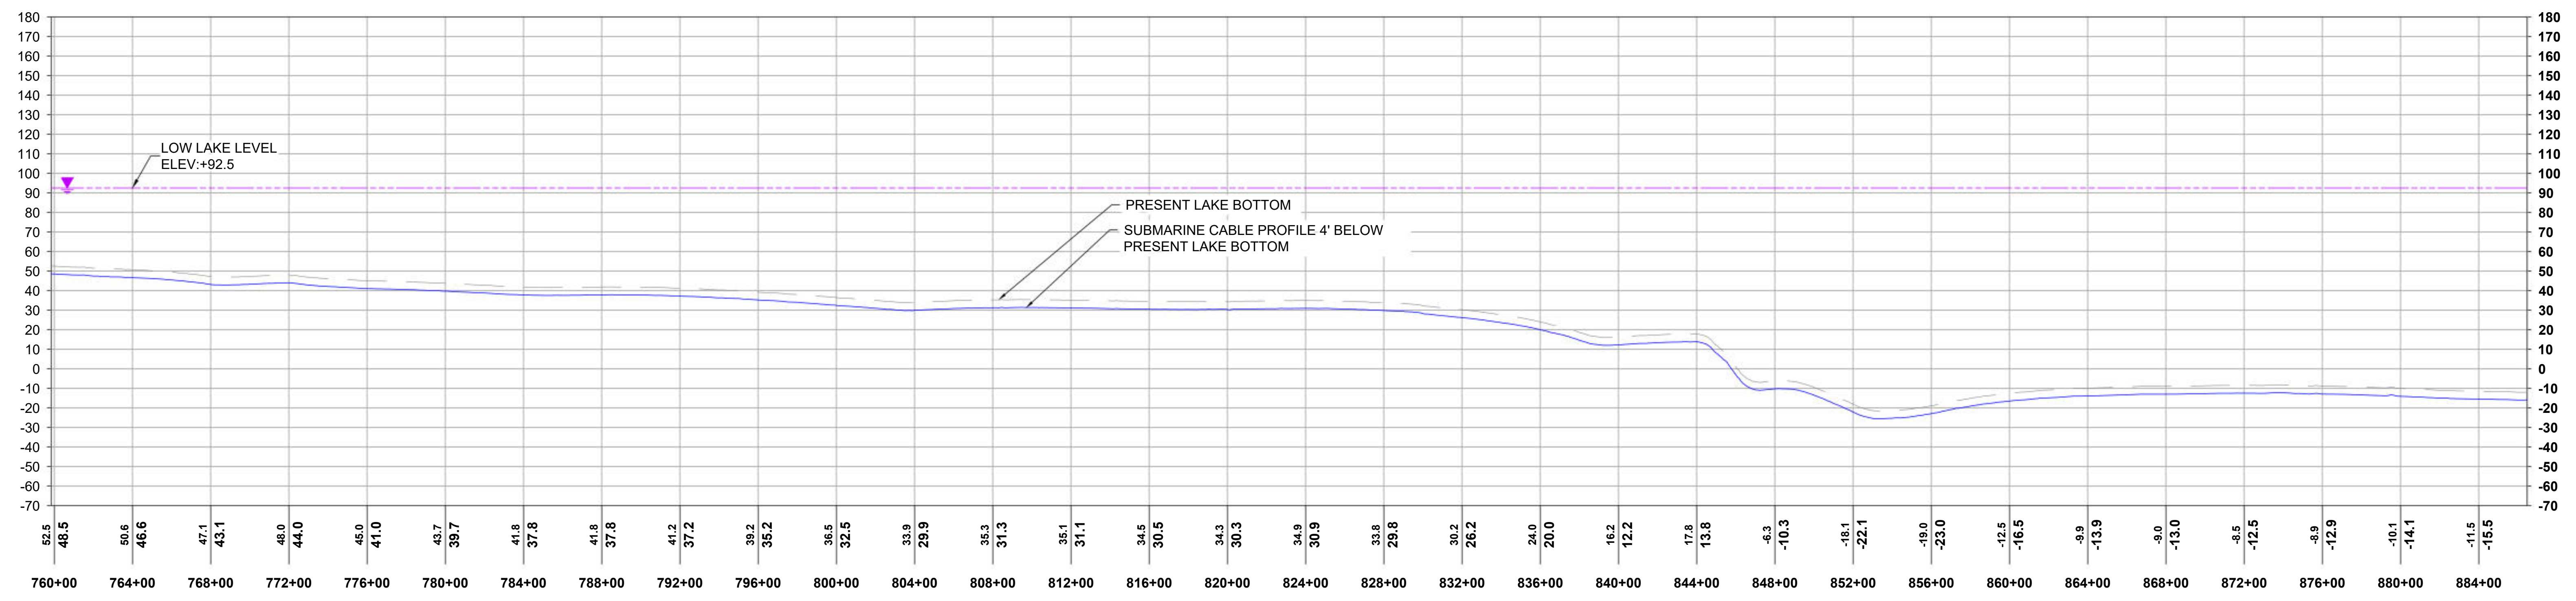

2 PROFILE VIEW
HORIZONTAL SCALE: 1"=400', VERTICAL SCALE: 1"=40'



Sharon L. Burke


REFERENCE DRAWINGS		REVISIONS					
DWG. NO.	TITLE	NO.	DESCRIPTION	DATE	DRAWN	CHK	APPR
		1	LLL ADDED PER NYS DPS REQUEST	03/29/2024	EYA	PRW	SB

DRAWING APPROVALS	
DRAWN	DATE
LDC	01/05/24
CHECKED	DATE
GJR	01/17/24
ENGINEER	DATE
SB	01/18/24


HORIZONTAL SCALE: 1"=400'

VERTICAL SCALE: 1"=40'


CHPE - LAKE CHAMPLAIN PROPOSED CABLE ROUTE EM&CP SEGMENT 18B PLAN & PROFILE STA 759+84.00 TO STA 886+48.00			
SCALE	PROJECT NO.	DRAWING NO.	SHT. NO.
1"=400'	532345	C-7	13

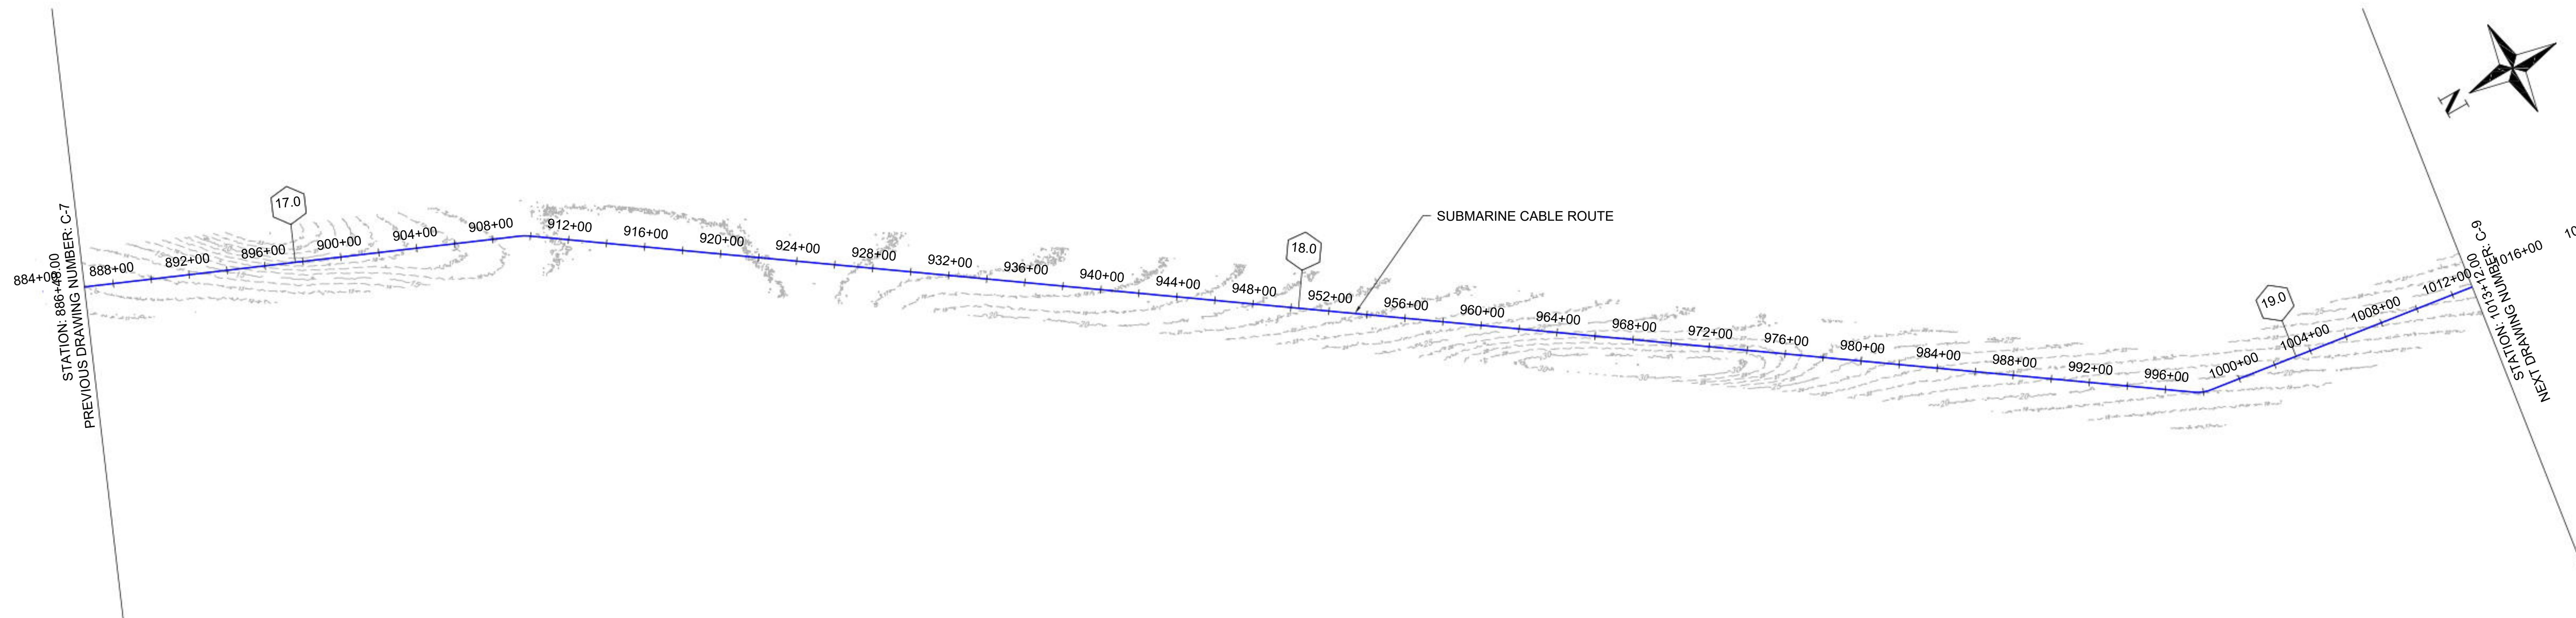

1 PLAN VIEW
SCALE: 1"=400'

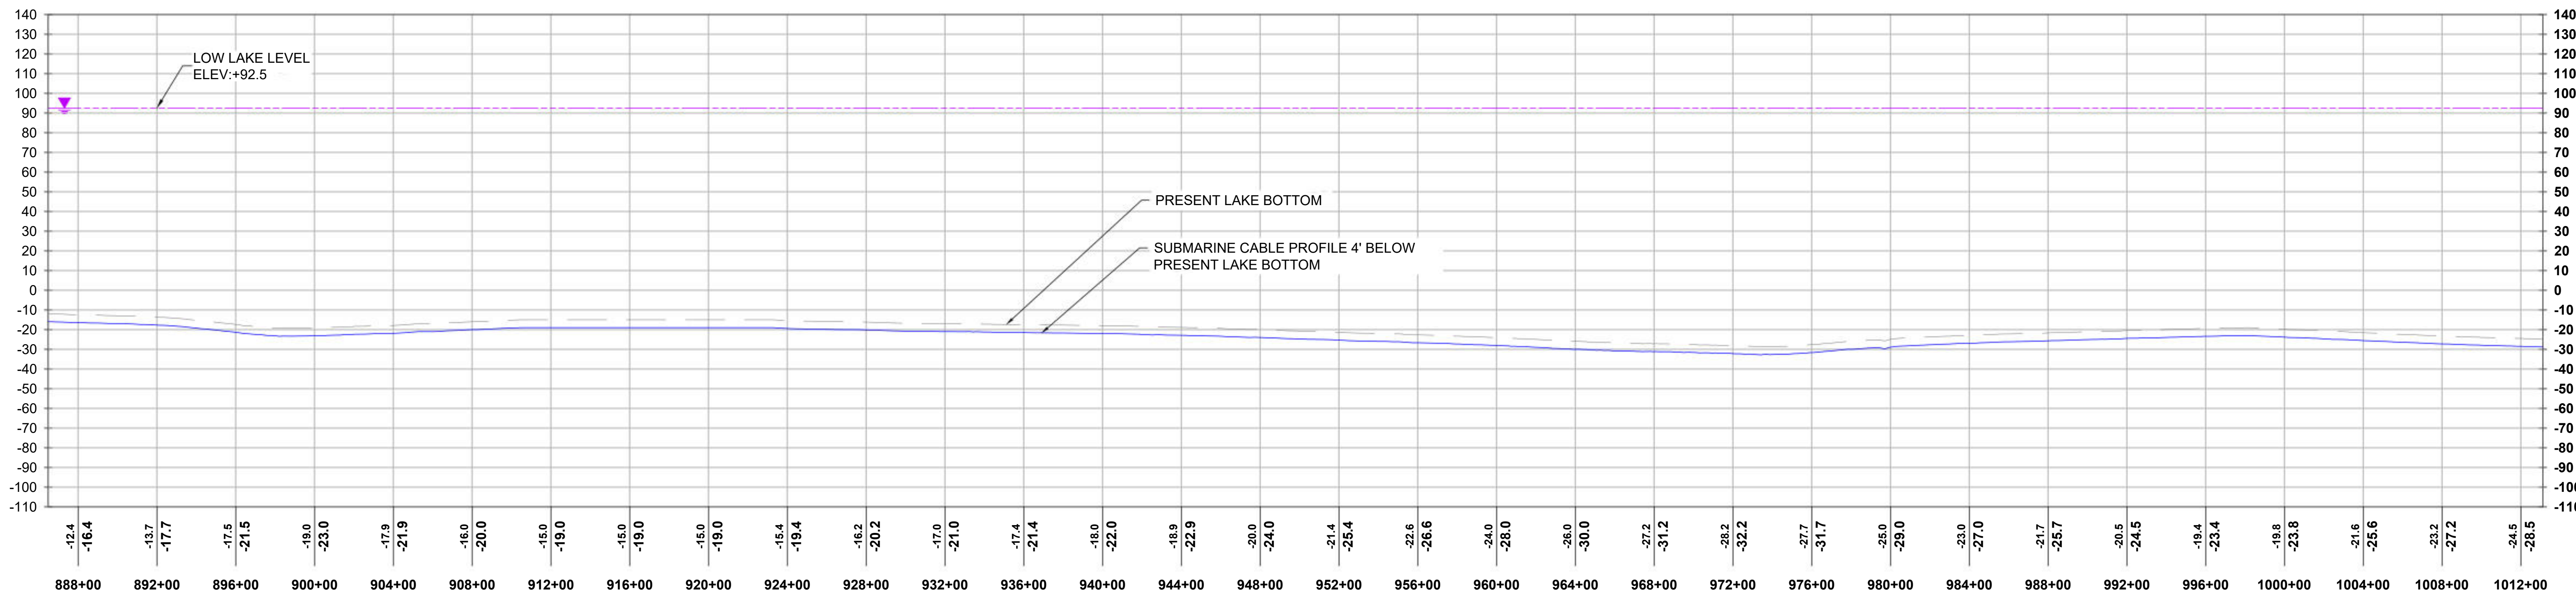

2 PROFILE VIEW
HORIZONTAL SCALE: 1"=400', VERTICAL SCALE: 1"=40'

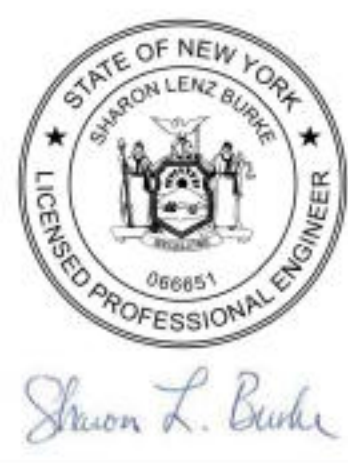

REFERENCE DRAWINGS	
DWG. NO.	TITLE


REVISIONS					
NO.	DESCRIPTION	DATE	DRAWN	CHK	APPR
1	LLL ADDED PER NYS DPS REQUEST	03/29/2024	EYA	PRW	SB

DRAWING APPROVALS	
DRAWN	DATE
LDC	01/05/24
CHECKED	DATE
GJR	01/17/24
ENGINEER	DATE
SB	01/18/24


HORIZONTAL SCALE: 1"=400'

VERTICAL SCALE: 1"=40'

CHPE - LAKE CHAMPLAIN PROPOSED CABLE ROUTE EM&CP SEGMENT 18B PLAN & PROFILE STA 886+48.00 TO STA 1013+12.00			
SCALE	PROJECT NO.	DRAWING NO.	SHT. NO.
1"=400'	532345	C-8	14

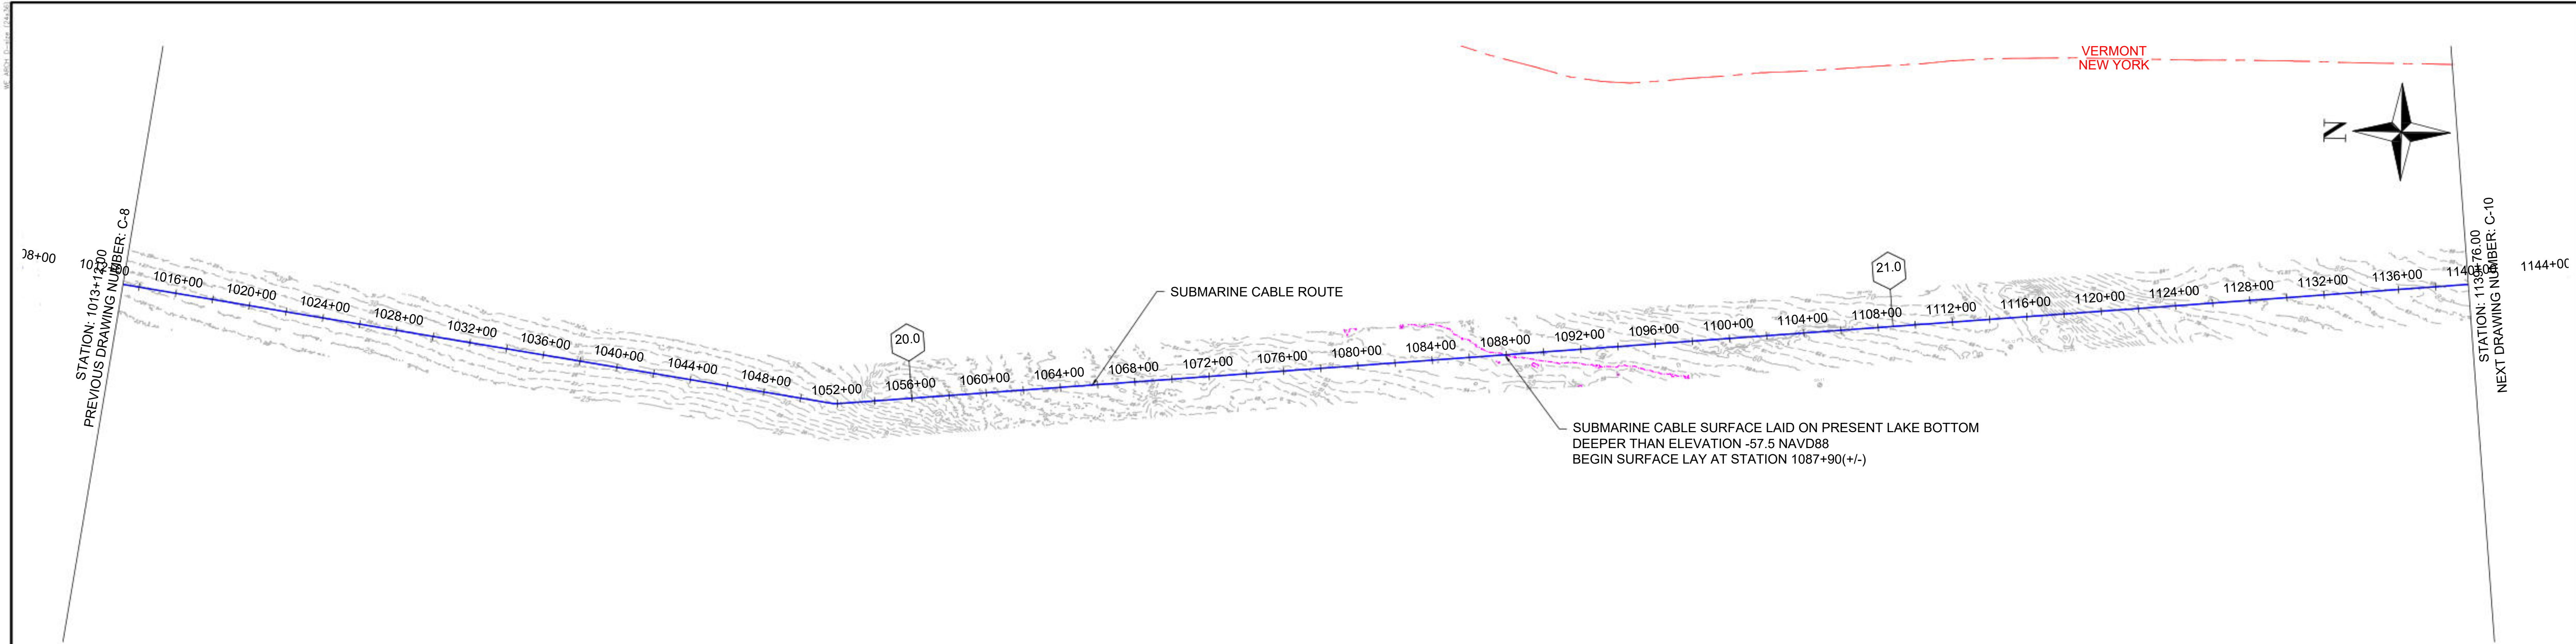

1 PLAN VIEW
SCALE: 1"=400'

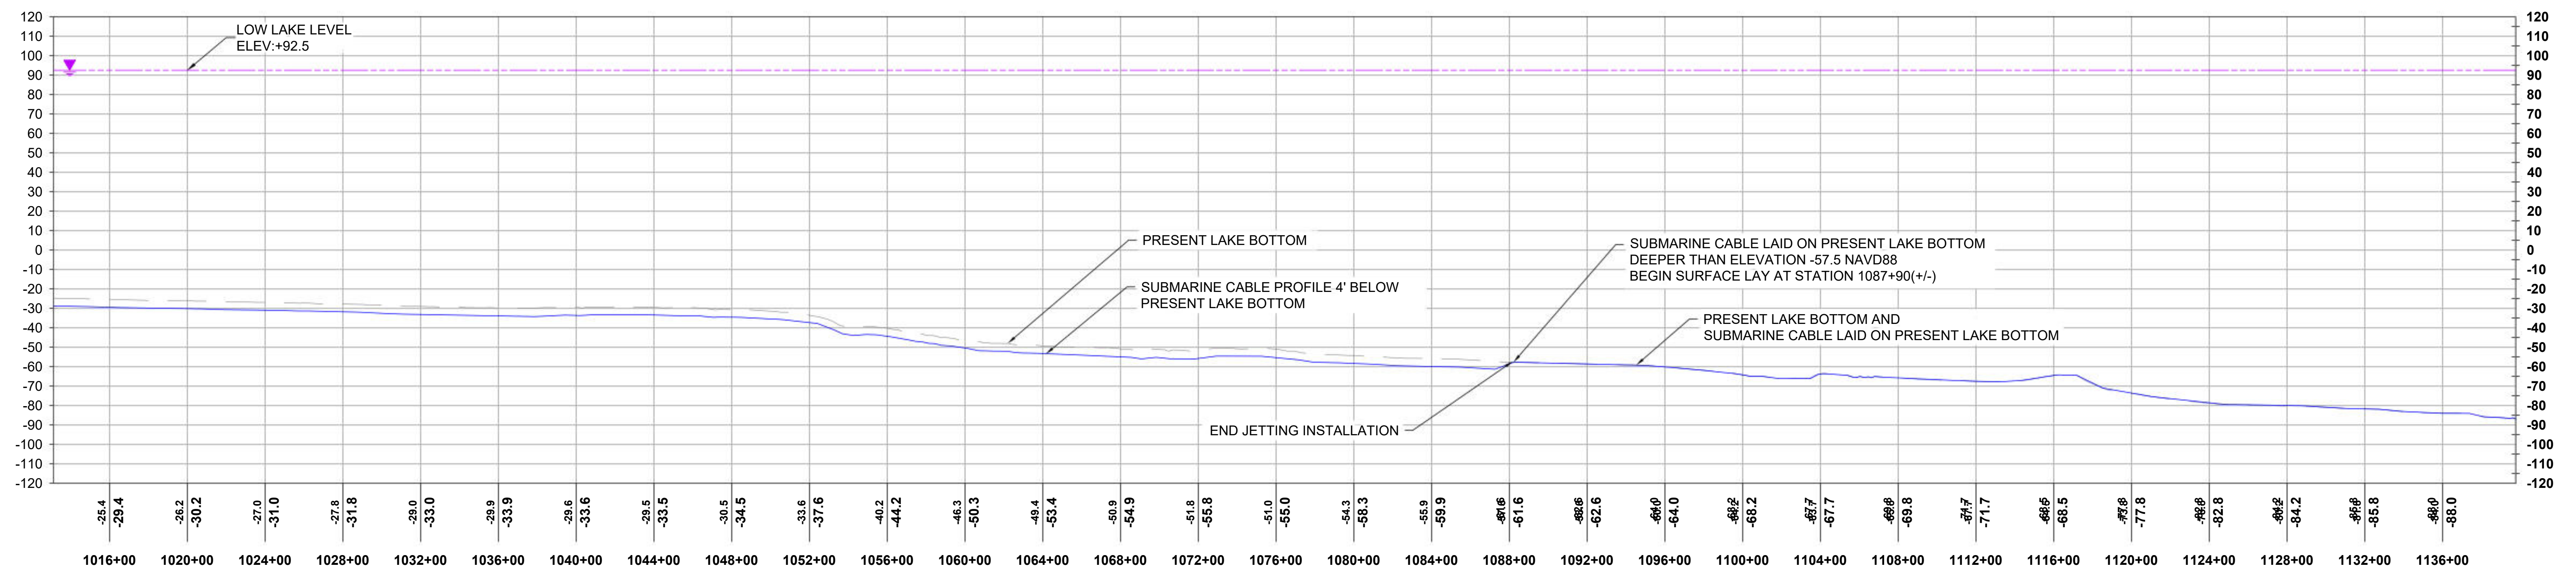

2 PROFILE VIEW
HORIZONTAL SCALE: 1"=400', VERTICAL SCALE: 1"=40'



REFERENCE DRAWINGS	
DWG. NO.	TITLE


REVISIONS					
NO.	DESCRIPTION	DATE	DRAWN	CHK	APPR
1	LLL ADDED PER NYS DPS REQUEST	03/29/2024	EYA	PRW	SB

DRAWING APPROVALS	
DRAWN	DATE
LDC	01/05/24
CHECKED	DATE
GJR	01/17/24
ENGINEER	DATE
SB	01/18/24


HORIZONTAL SCALE: 1"=400'

VERTICAL SCALE: 1"=40'

CHPE - LAKE CHAMPLAIN PROPOSED CABLE ROUTE EM&CP SEGMENT 18B PLAN & PROFILE STA 1013+12.00 TO STA 1139+76.00			
SCALE	PROJECT NO.	DRAWING NO.	SHT. NO.
1"=400'	532345	C-9	15

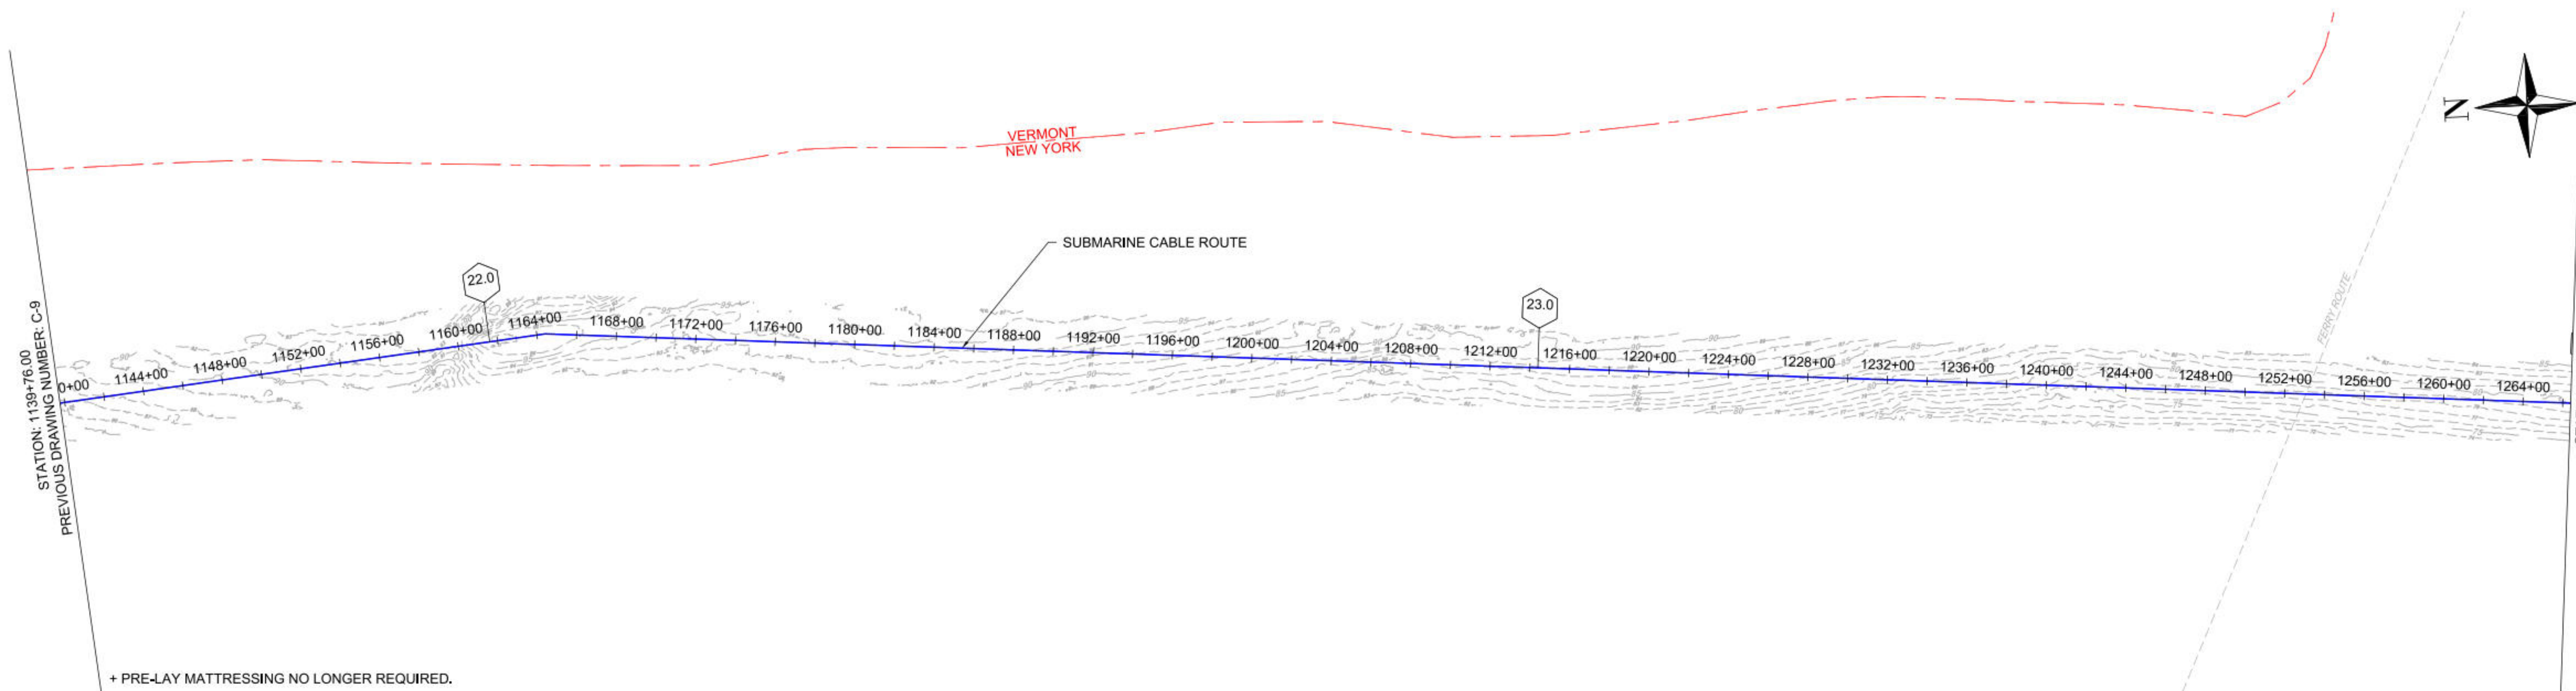

1 PLAN VIEW
SCALE: 1"=400'

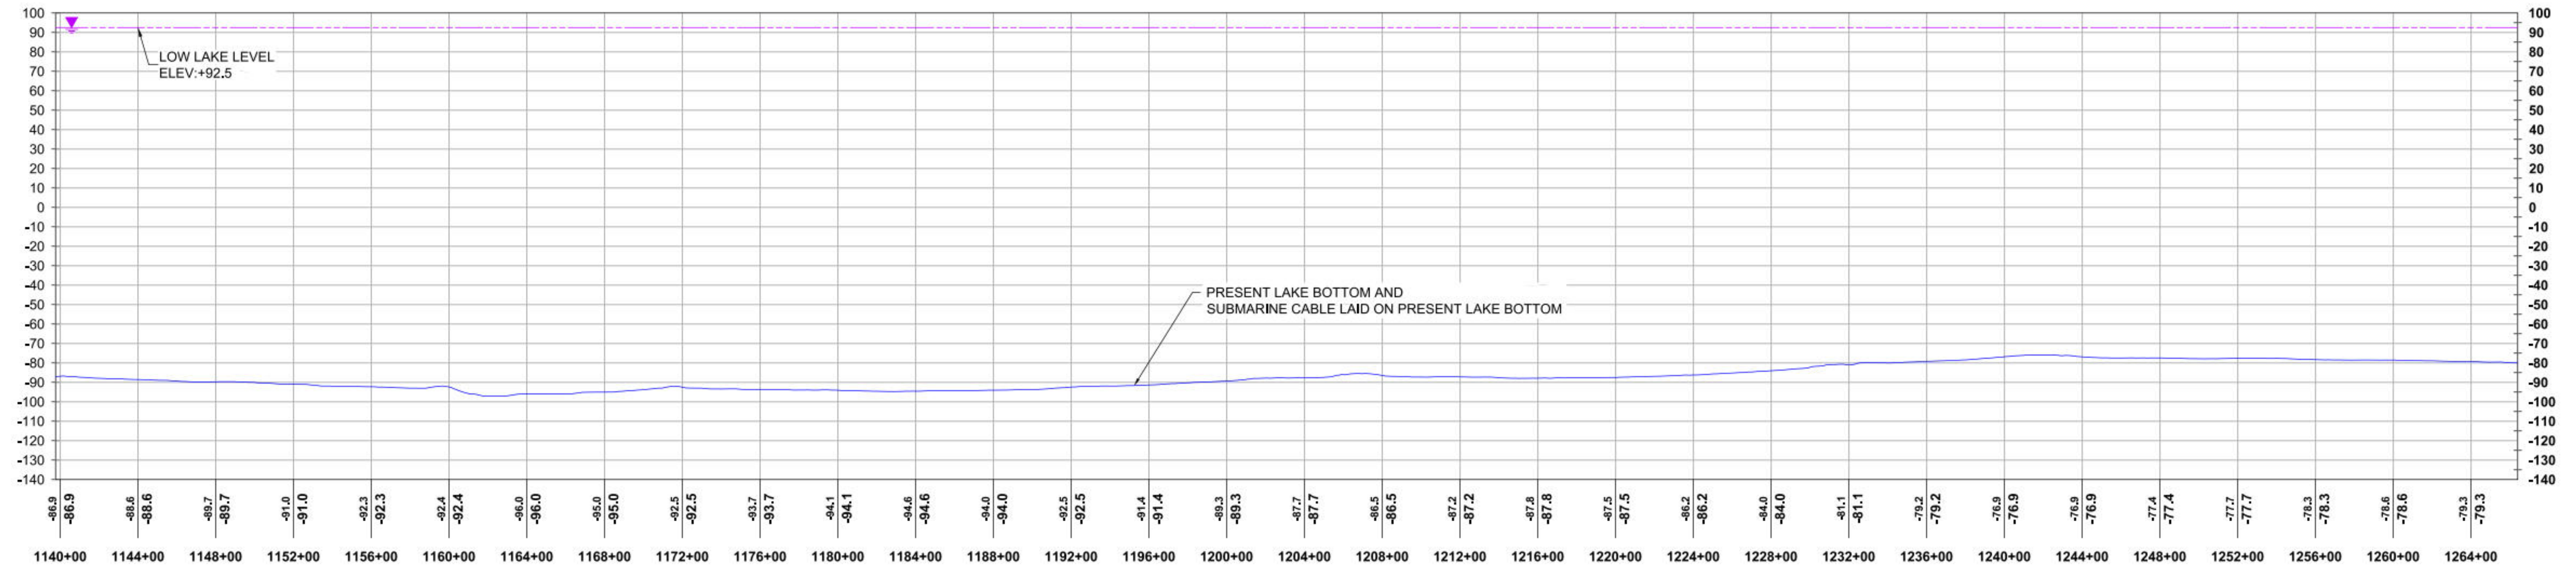

2 PROFILE VIEW
HORIZONTAL SCALE: 1"=400', VERTICAL SCALE: 1"=40'



Sharon L. Burke

REFERENCE DRAWINGS	
DWG. NO.	TITLE

REVISIONS						
NO.	DESCRIPTION	DATE	DRAWN	CHK	APPR	
1	LLL ADDED PER NYS DPS REQUEST	03/29/2024	EYA	PRW	SB	


DRAWING APPROVALS	
DRAWN	DATE
LDC	01/05/24
CHECKED	DATE
GJR	01/17/24
ENGINEER	DATE
SB	01/18/24

HORIZONTAL SCALE: 0 400'


VERTICAL SCALE: 0 40'

CHPE - LAKE CHAMPLAIN PROPOSED CABLE ROUTE
EM&CP SEGMENT 18B
PLAN & PROFILE STA 1139+76.00 TO STA 1266+40.00

SCALE	PROJECT NO.	DRAWING NO.	SHT. NO.
1"=400'	532345	C-10	16

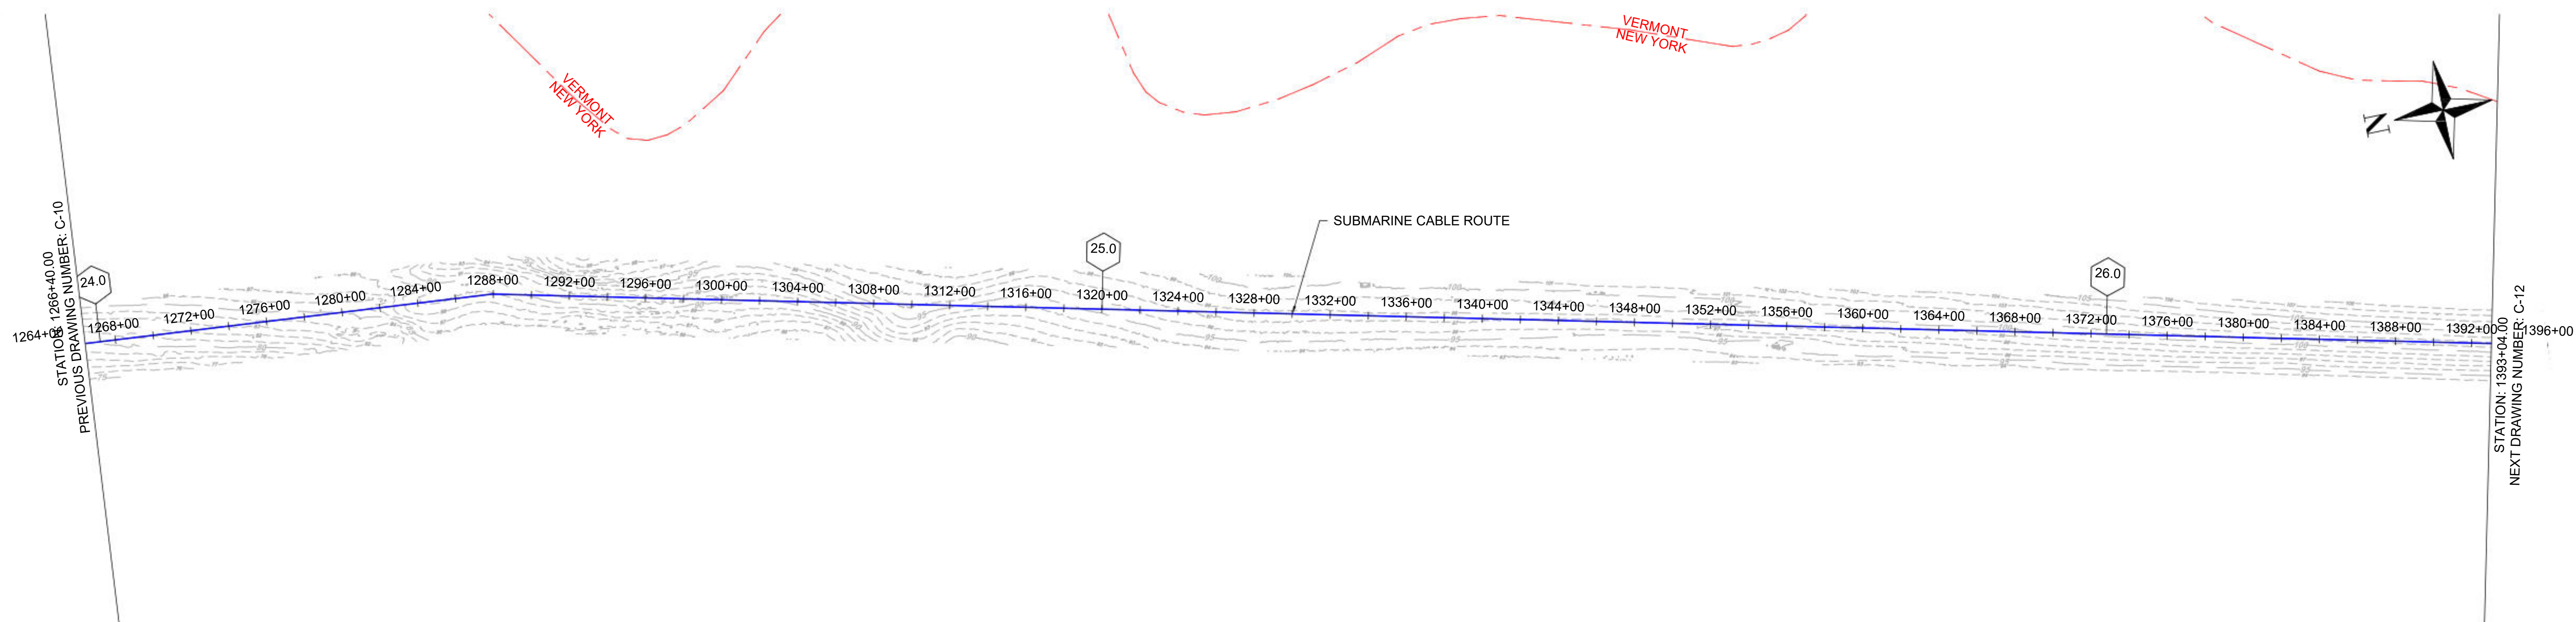

1 PLAN VIEW
SCALE: 1"=400'

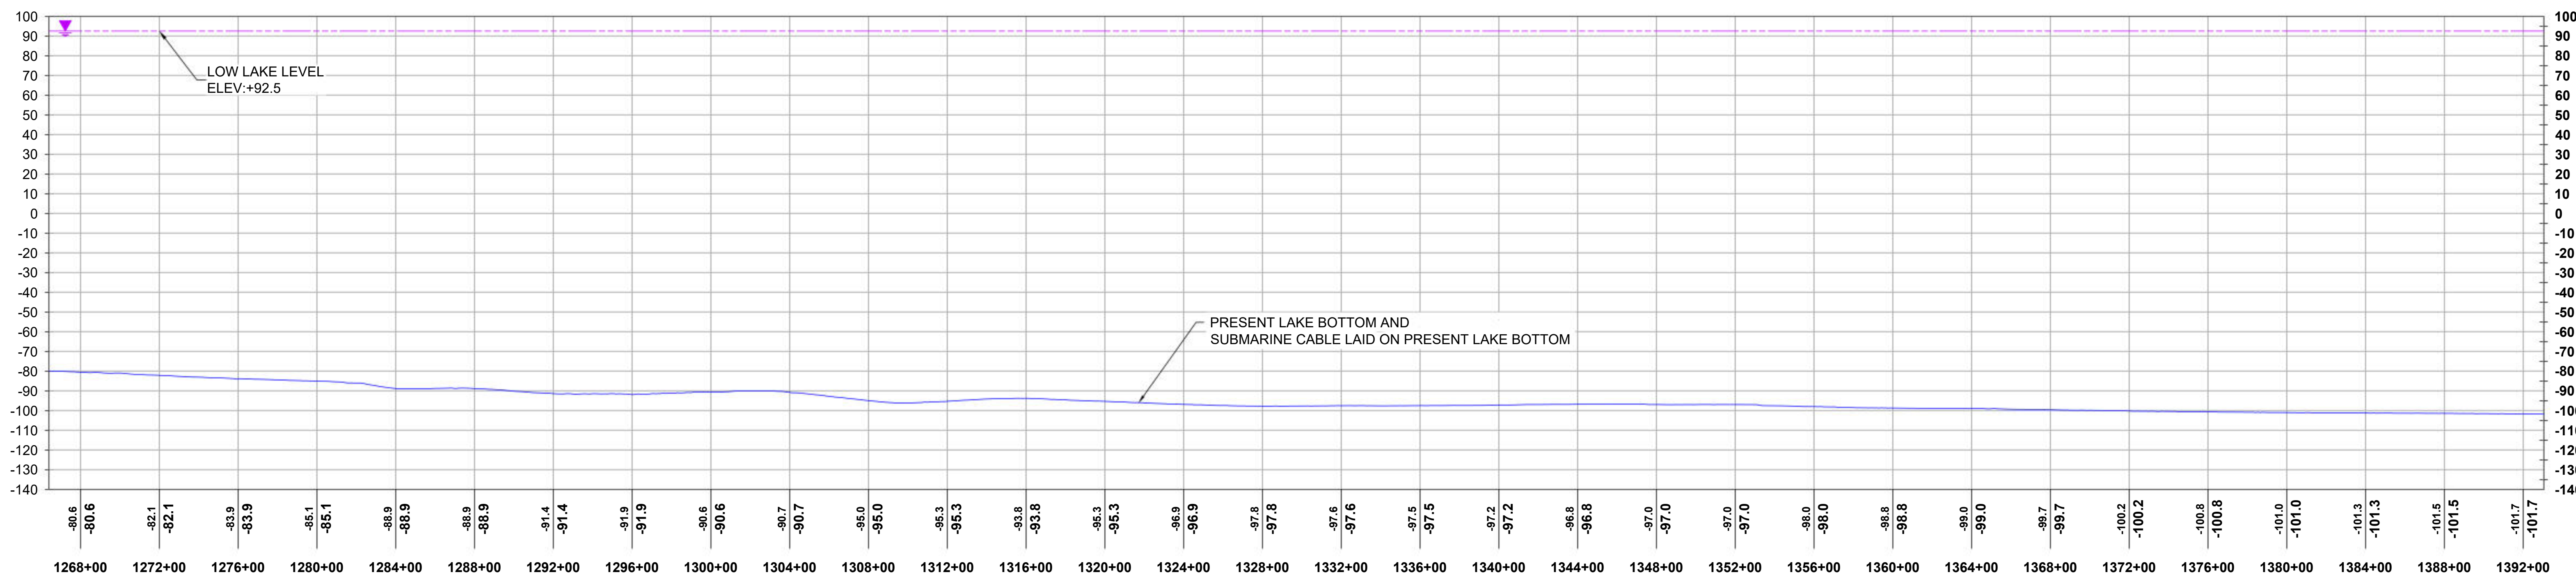

2 PROFILE VIEW
HORIZONTAL SCALE: 1"=400', VERTICAL SCALE: 1"=40'



REFERENCE DRAWINGS	
DWG. NO.	TITLE


REVISIONS					
NO.	DESCRIPTION	DATE	DRAWN	CHK	APPR
1	LLL ADDED PER NYS DPS REQUEST	03/29/2024	EYA	PRW	SB

DRAWING APPROVALS	
DRAWN	DATE
LDC	01/05/24
CHECKED	DATE
GJR	01/17/24
ENGINEER	DATE
SB	01/18/24


HORIZONTAL SCALE: 1"=400'

VERTICAL SCALE: 1"=40'

CHPE - LAKE CHAMPLAIN PROPOSED CABLE ROUTE EM&CP SEGMENT 18B PLAN & PROFILE STA 1266+40.00 TO STA 1393+04.00			
SCALE	PROJECT NO.	DRAWING NO.	SHT. NO.
1"=400'	532345	C-11	17

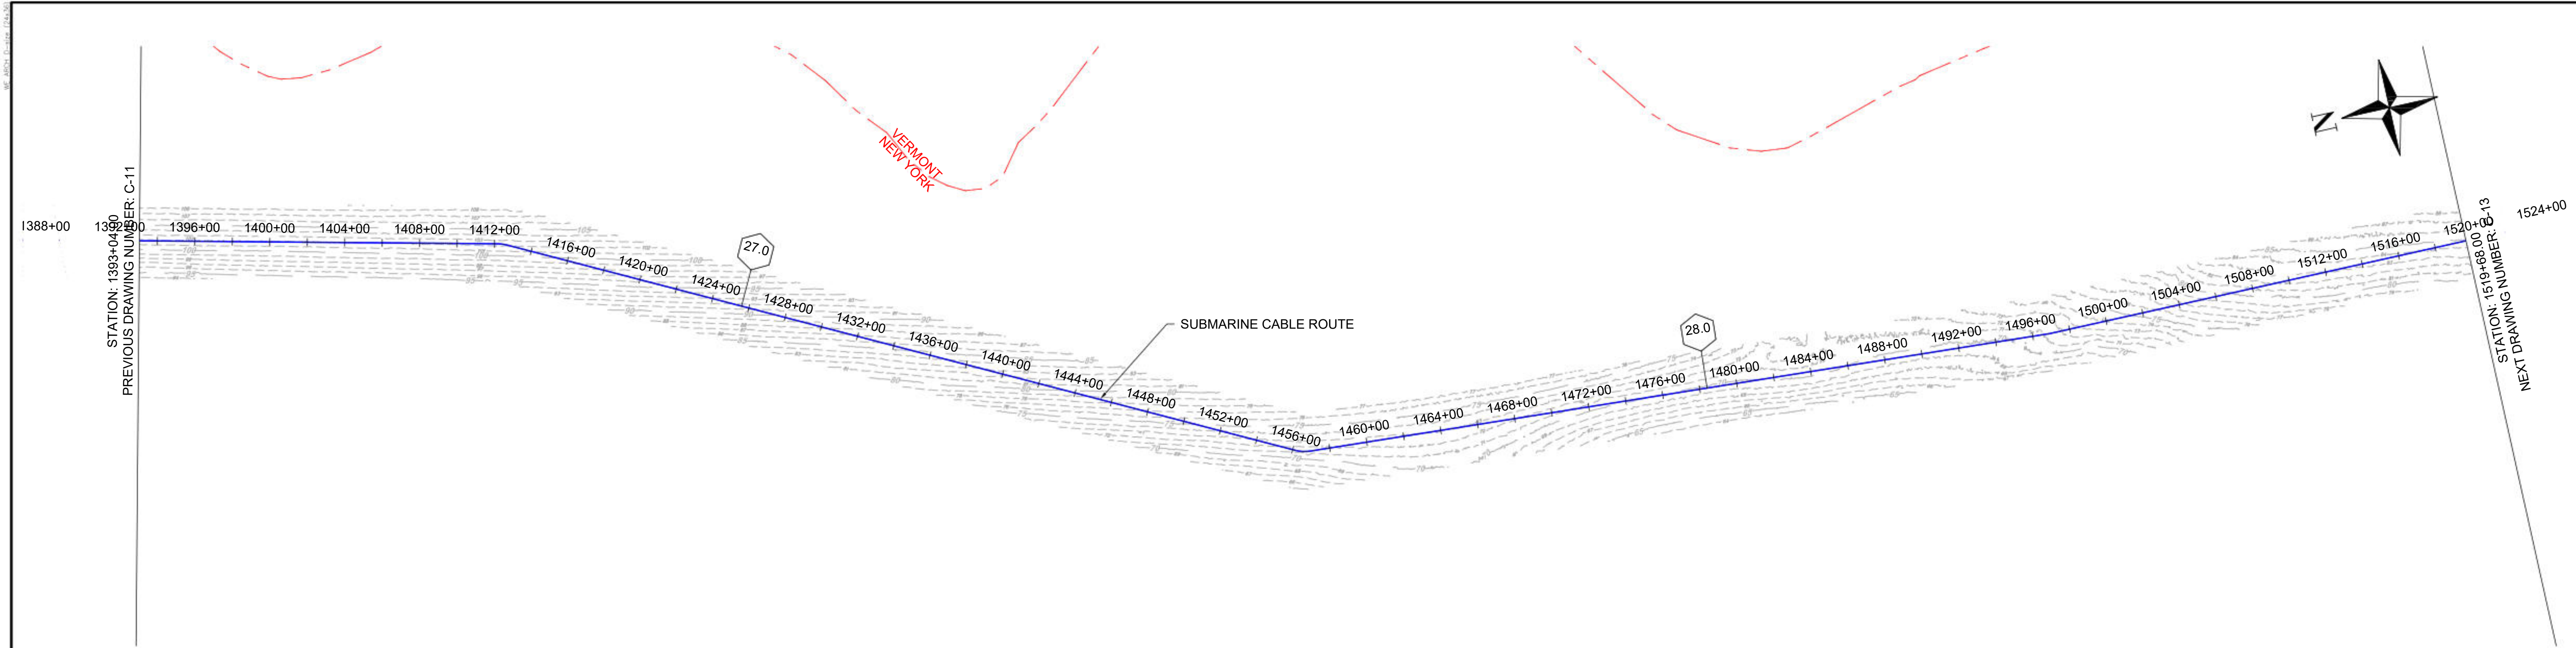

1 PLAN VIEW
SCALE: 1"=400'

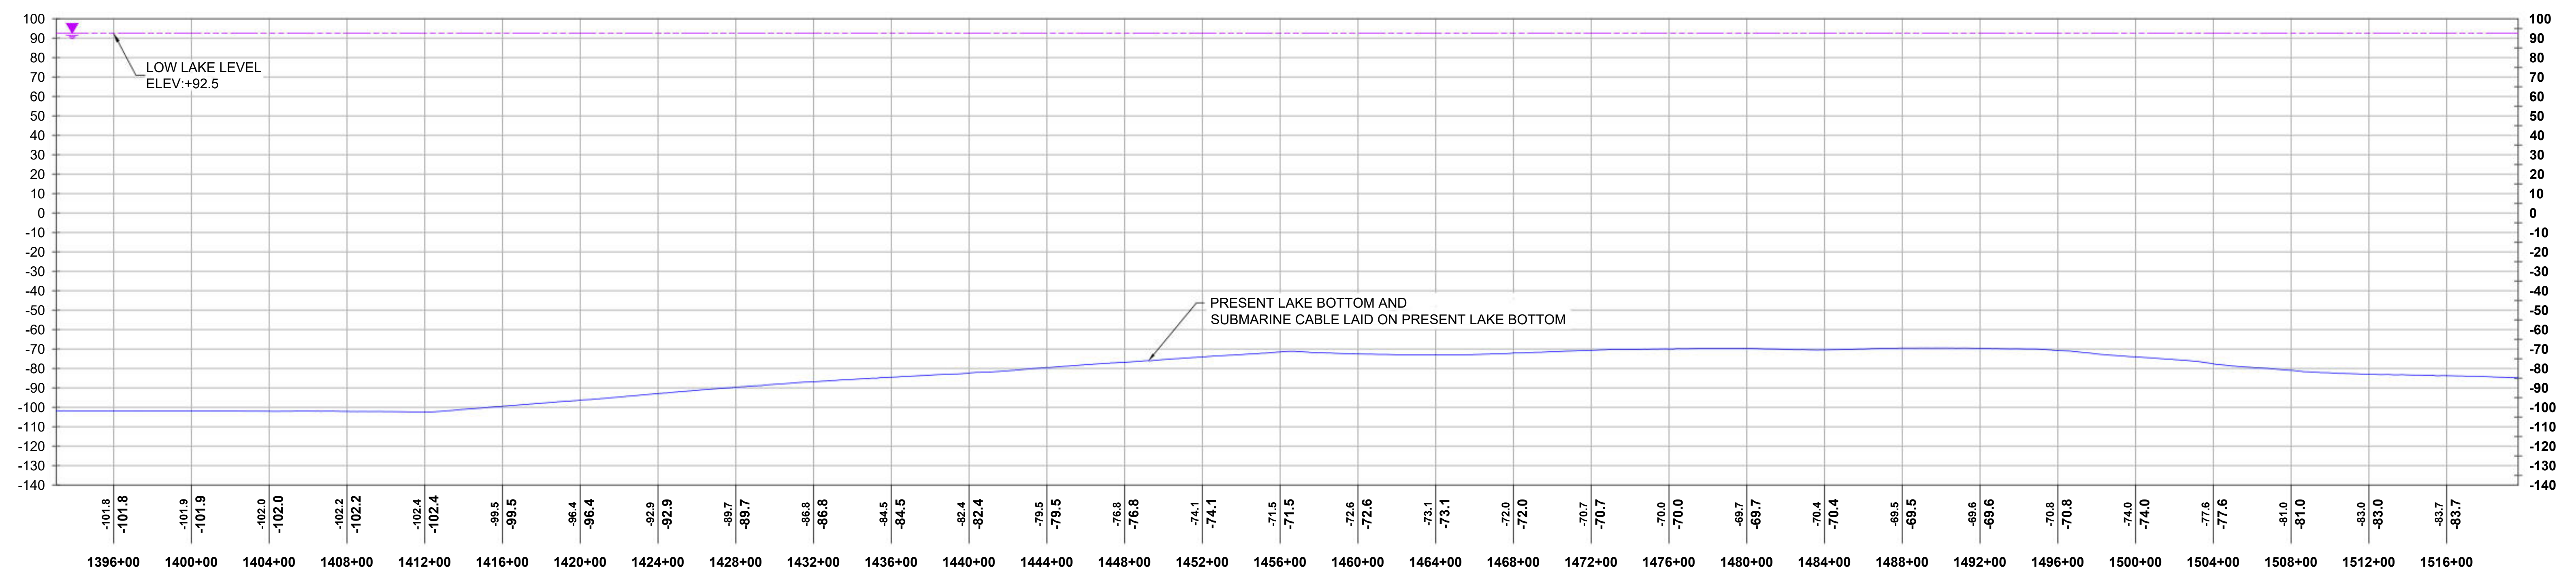

2 PROFILE VIEW
HORIZONTAL SCALE: 1"=400', VERTICAL SCALE: 1"=40'



REFERENCE DRAWINGS	
DWG. NO.	TITLE


REVISIONS					
NO.	DESCRIPTION	DATE	DRAWN	CHK	APPR
1	LLL ADDED PER NYS OPS REQUEST	03/29/2024	EYA	PRW	SB

DRAWING APPROVALS	
DRAWN	DATE
LDC	01/05/24
CHECKED	DATE
GJR	01/17/24
ENGINEER	DATE
SB	01/18/24


HORIZONTAL SCALE: 1"=400'

VERTICAL SCALE: 1"=40'

CHPE - LAKE CHAMPLAIN PROPOSED CABLE ROUTE EM&CP SEGMENT 18B PLAN & PROFILE STA 1393+04.00 TO STA 1519+68.00			
SCALE	PROJECT NO.	DRAWING NO.	SHT. NO.
1"=400'	532345	C-12	18

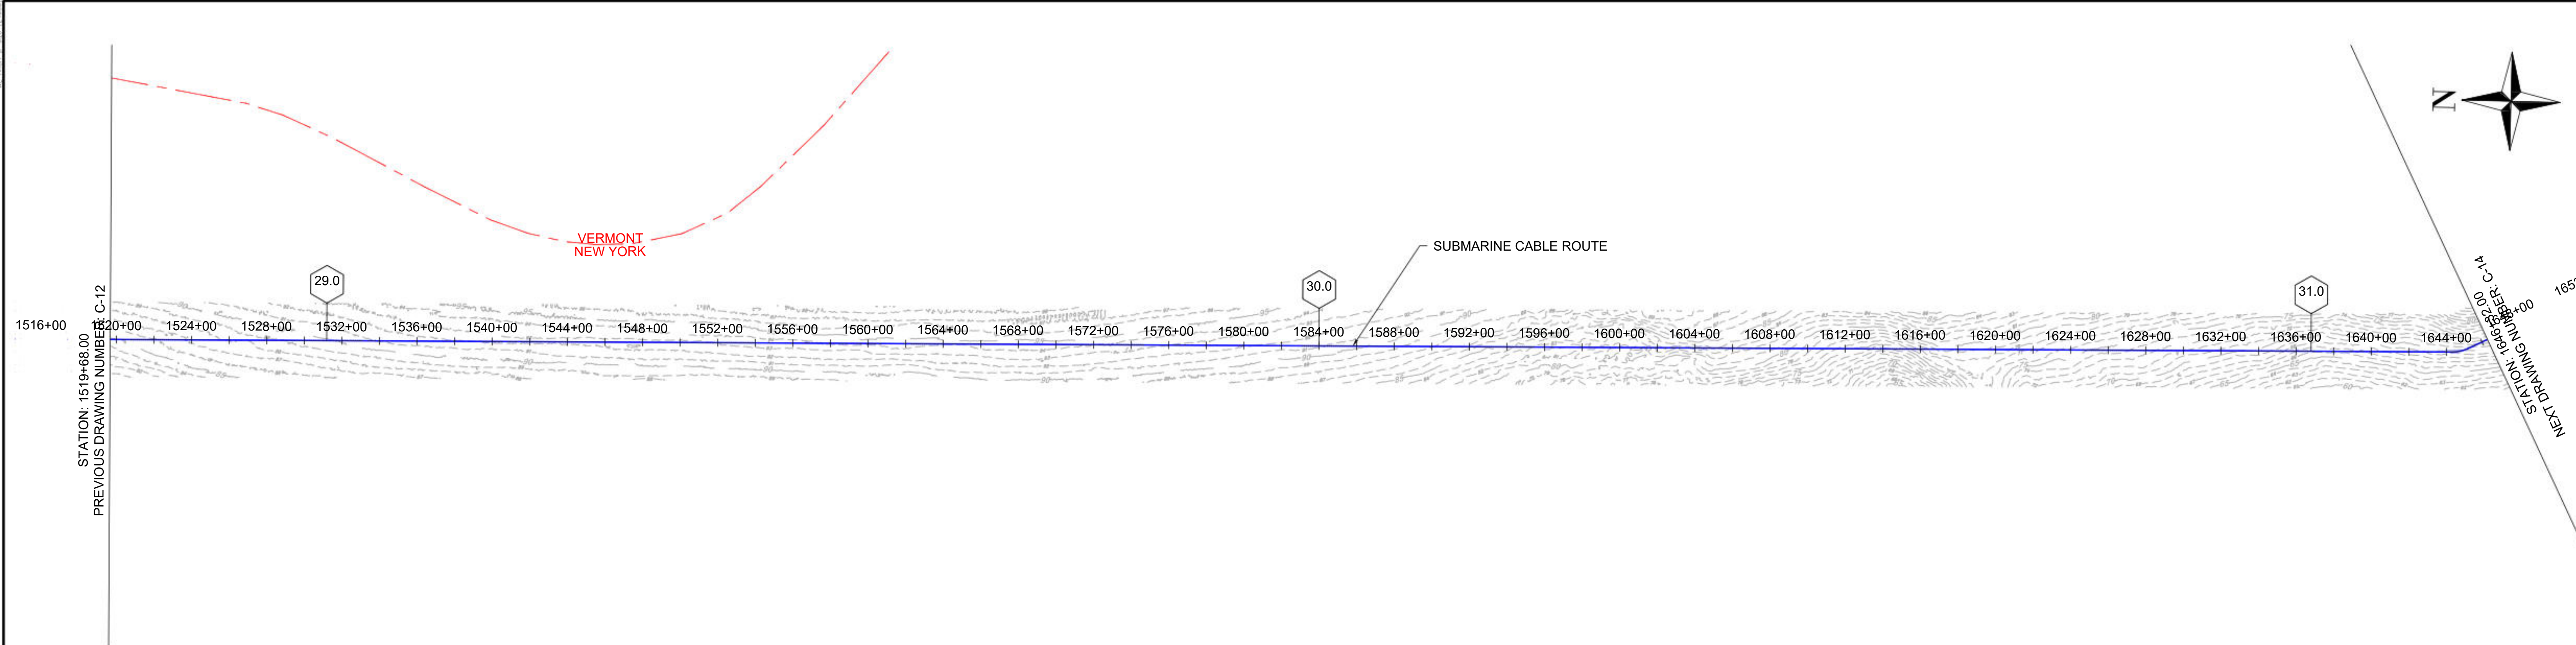

1 PLAN VIEW
SCALE: 1"=400'

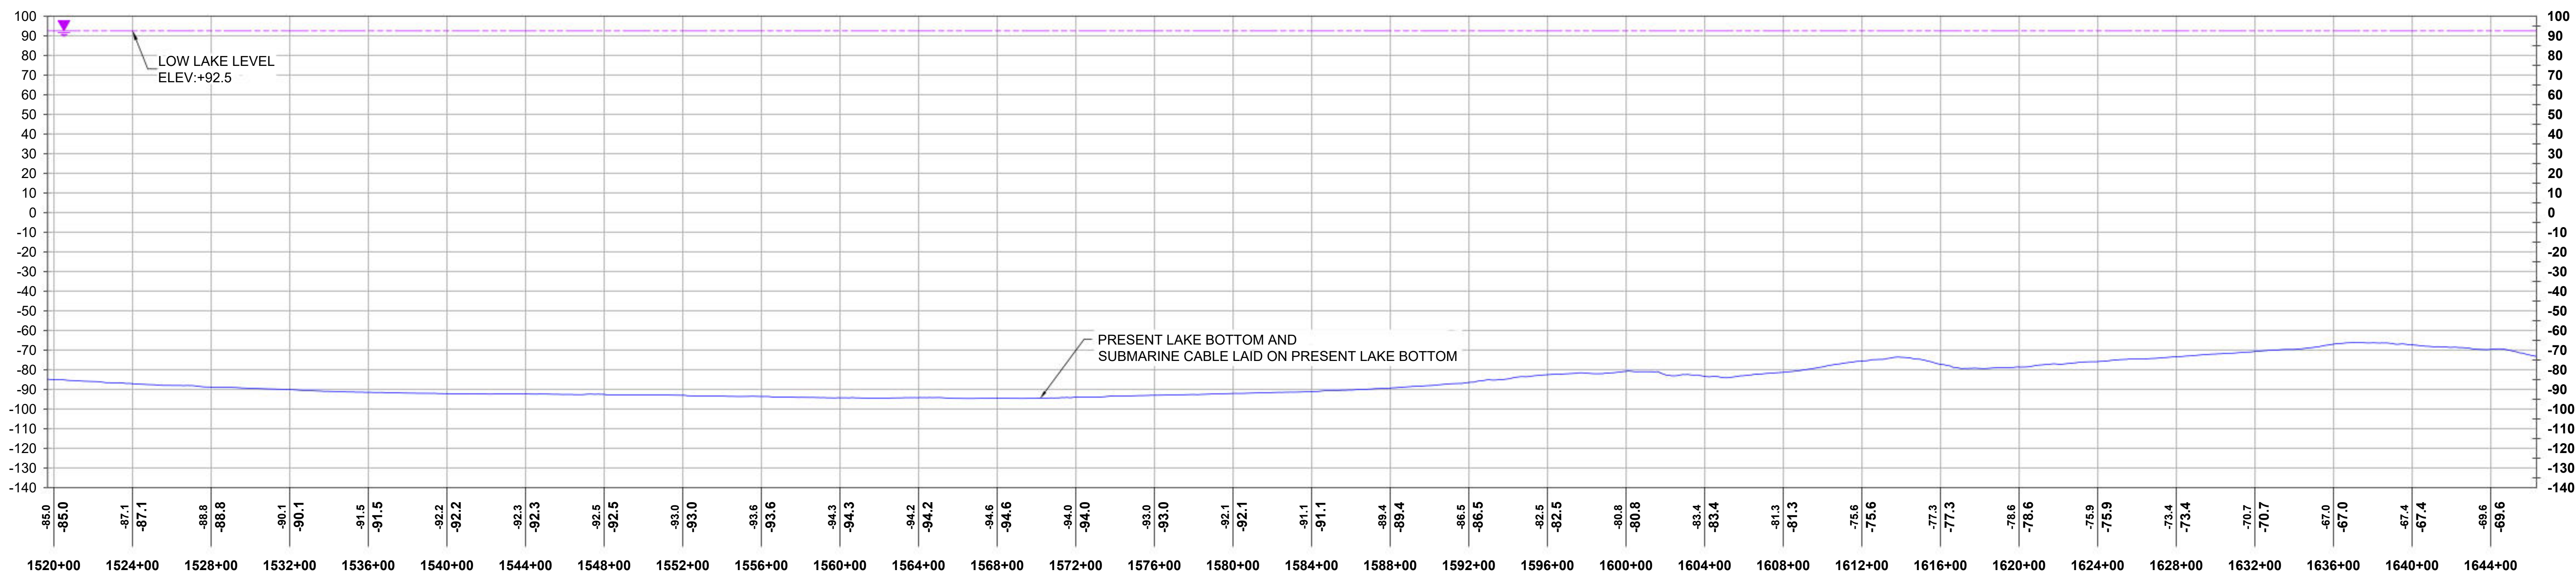

2 PROFILE VIEW
HORIZONTAL SCALE: 1"=400', VERTICAL SCALE: 1"=40'



Sharon L. Burke

REFERENCE DRAWINGS


DWG. NO.	TITLE

REVISIONS

NO.	DESCRIPTION	DATE	DRAWN	CHK	APPR
1	LLL ADDED PER NYS DPS REQUEST	03/29/2024	EYA	PRW	SB


DRAWING APPROVALS

DRAWN	DATE
LDC	01/05/24
CHECKED	DATE
GJR	01/17/24
ENGINEER	DATE
SB	01/18/24

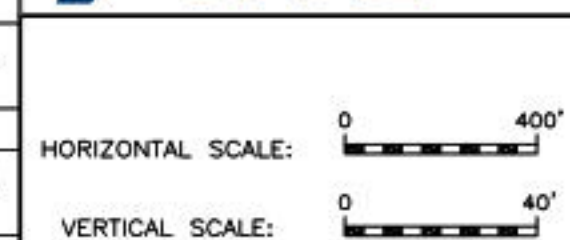


CHPE - LAKE CHAMPLAIN PROPOSED CABLE ROUTE
EM&CP SEGMENT 18B
PLAN & PROFILE STA 1519+68.00 TO STA 1646+32.00

SCALE	PROJECT NO.	DRAWING NO.	SHT. NO.
1"=400'	532345	C-13	19

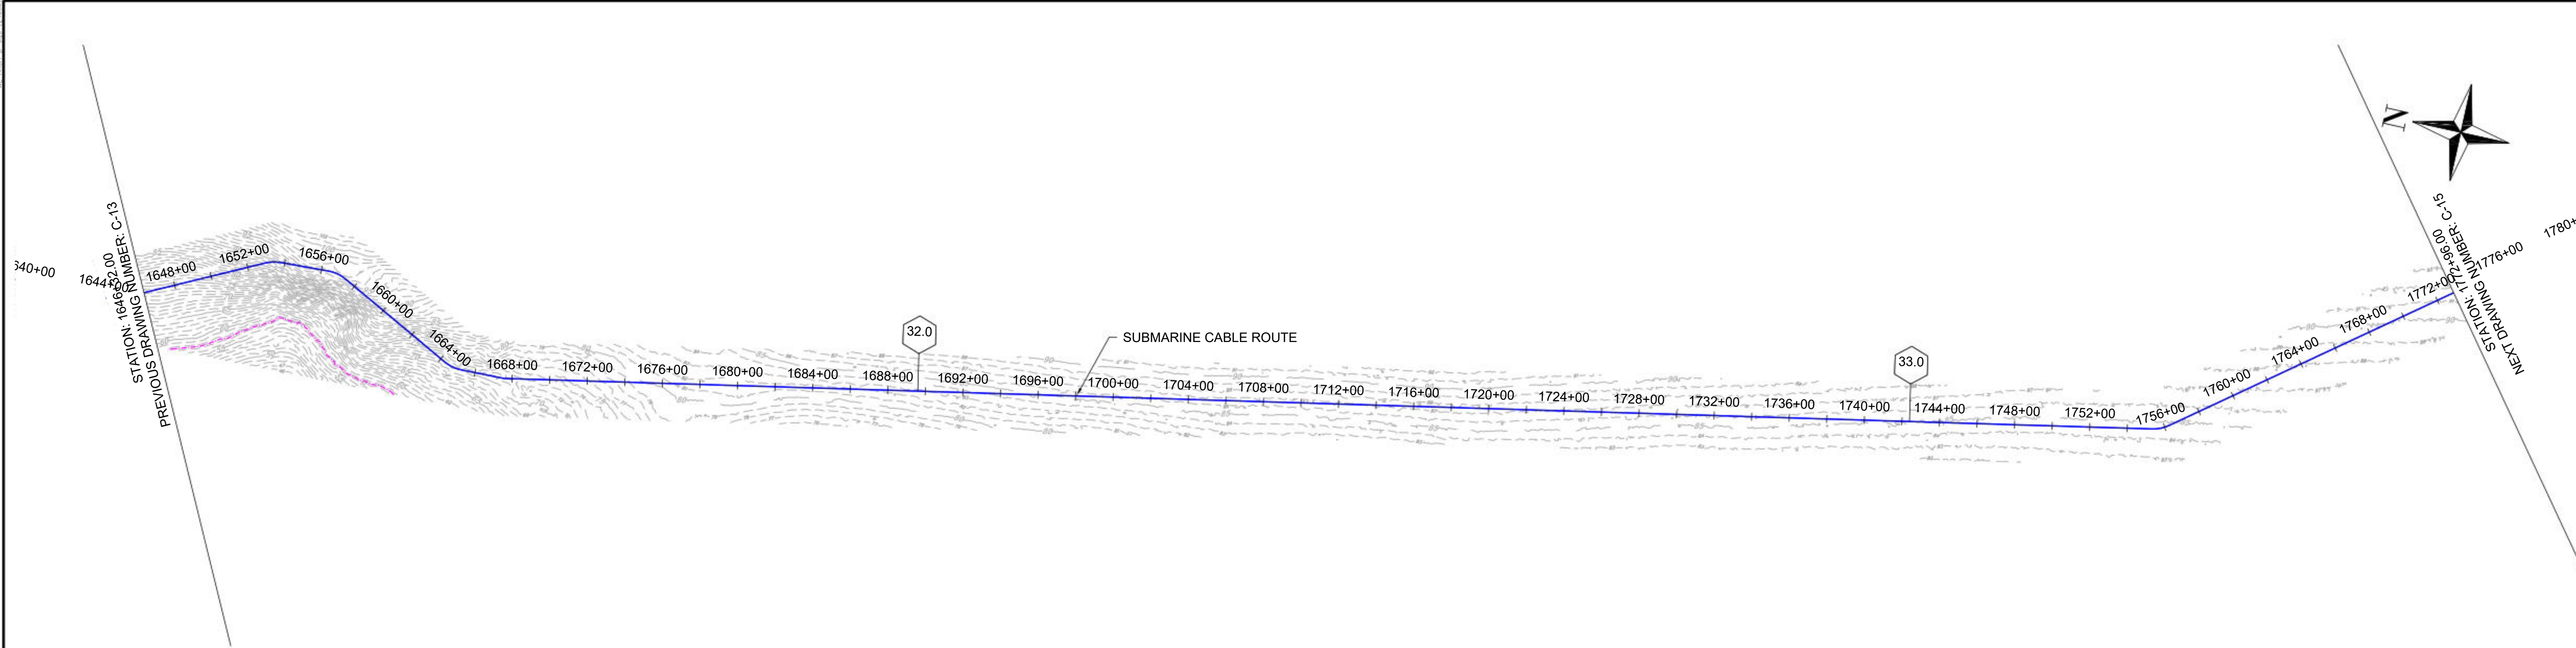

1 PLAN VIEW
SCALE: 1"=400'

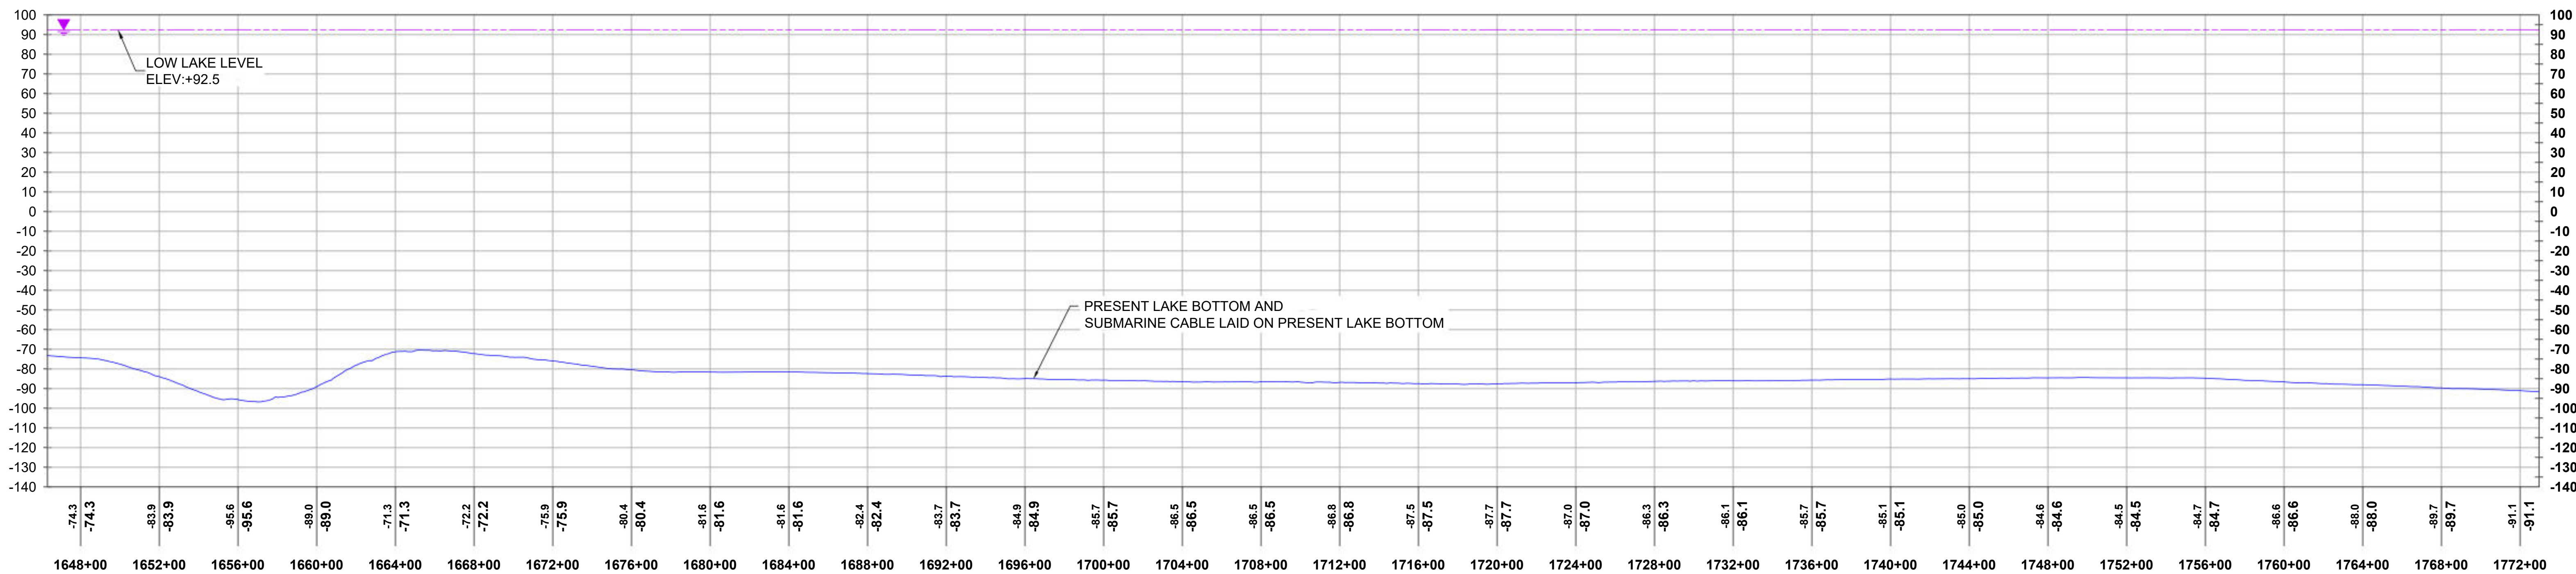

2 PROFILE VIEW
HORIZONTAL SCALE: 1"=400', VERTICAL SCALE: 1"=40'



Sharon L. Burke

REFERENCE DRAWINGS


DWG. NO.	TITLE

REVISIONS

NO.	DESCRIPTION	DATE	DRAWN	CHK	APPR
1	LLL ADDED PER NYS OPS REQUEST	03/29/2024	EYA	PRW	SB


DRAWING APPROVALS

DRAWN	DATE
LDC	01/05/24
CHECKED	DATE
GJR	01/17/24
ENGINEER	DATE
SB	01/18/24

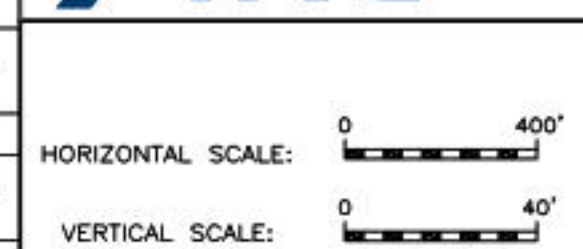


CHPE - LAKE CHAMPLAIN PROPOSED CABLE ROUTE
EM&CP SEGMENT 18B
PLAN & PROFILE STA 1646+32.00 TO STA 1772+96.00

SCALE	PROJECT NO.	DRAWING NO.	SHT. NO.
1"=400'	532345	C-14	20

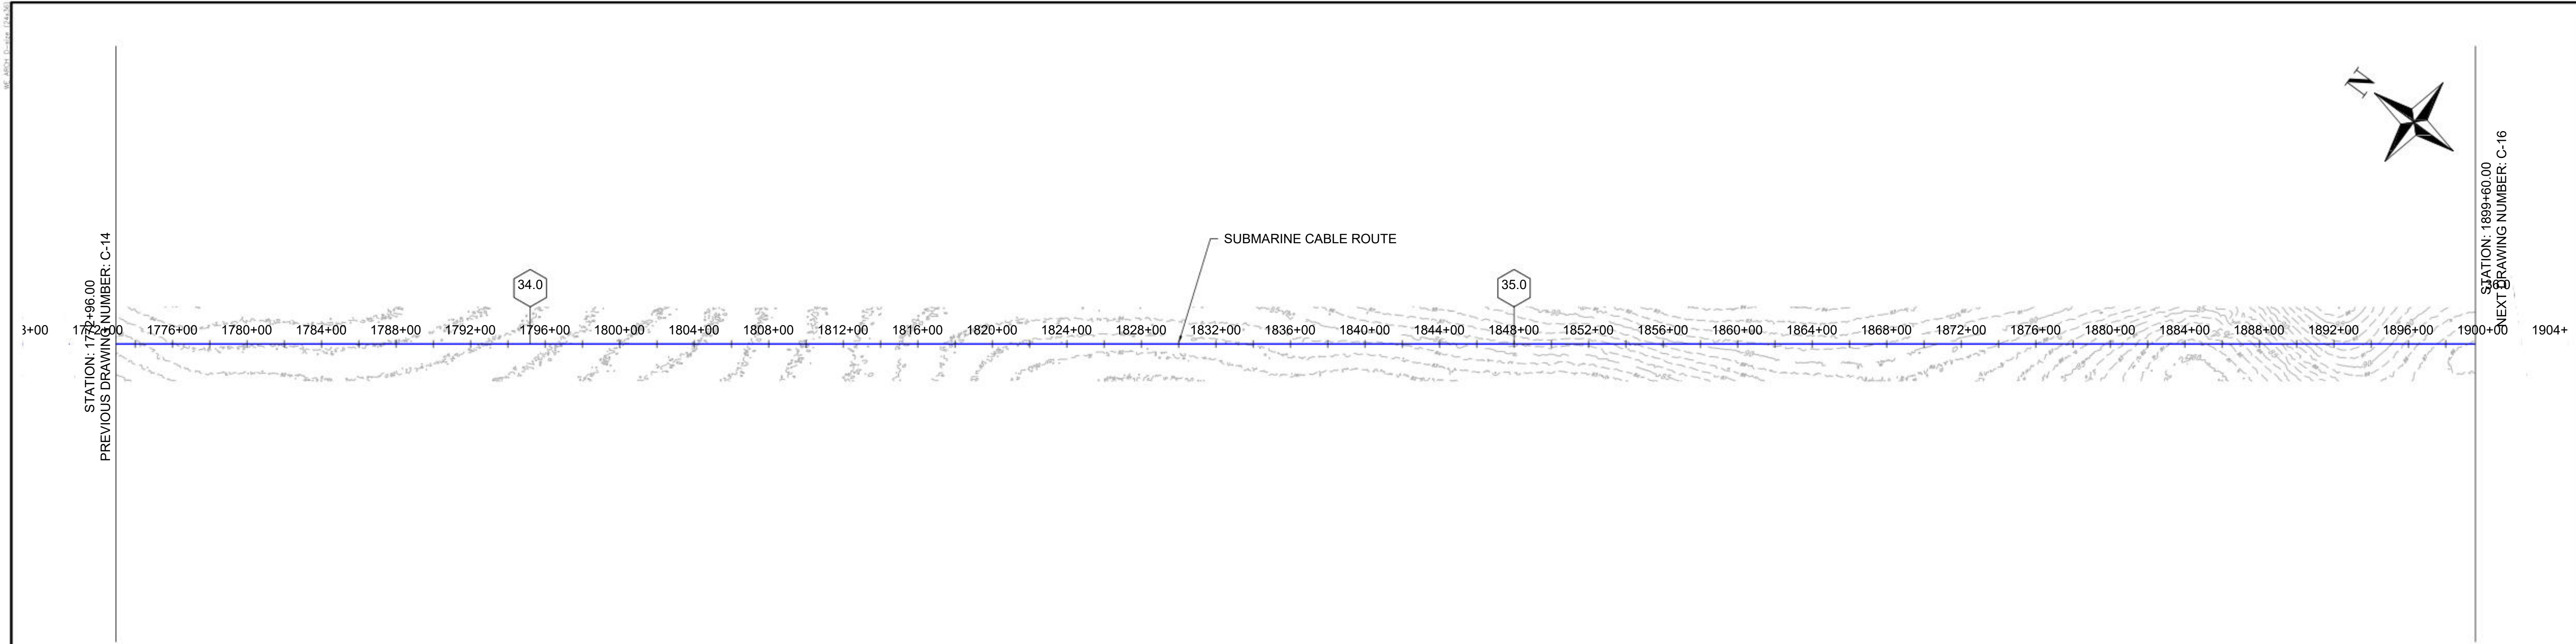

1 PLAN VIEW
SCALE: 1"=400'

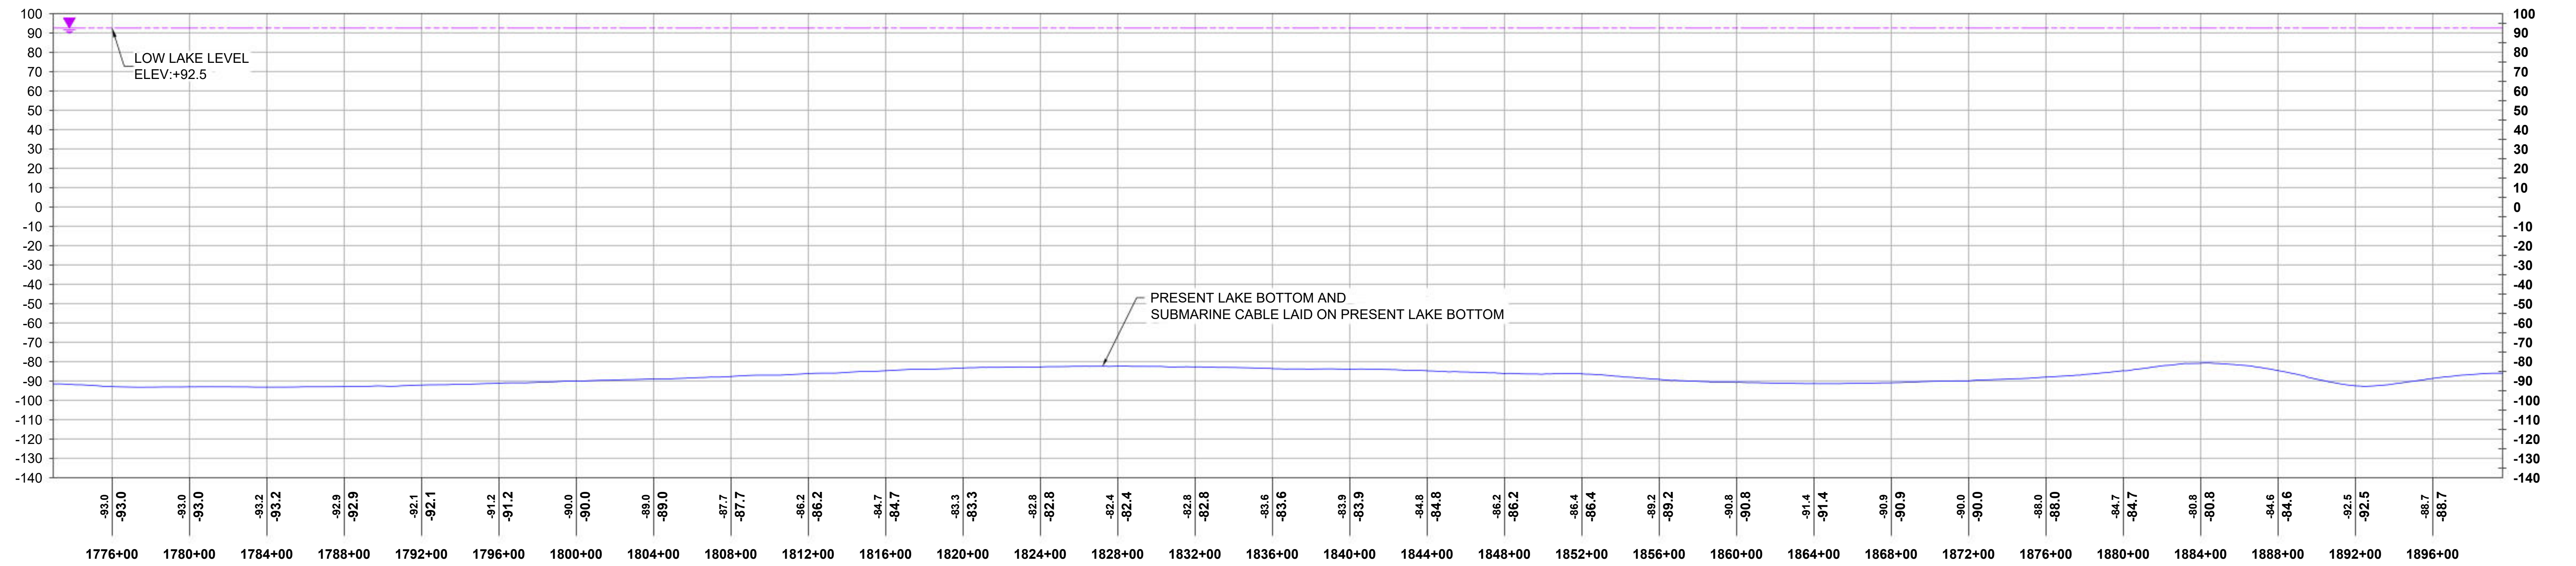

2 PROFILE VIEW
HORIZONTAL SCALE: 1"=400', VERTICAL SCALE: 1"=40'



REFERENCE DRAWINGS	
DWG. NO.	TITLE

REVISIONS					
NO.	DESCRIPTION	DATE	DRAWN	CHK	APPR
1	LLL ADDED PER NYS OPS REQUEST	03/29/2024	EYA	PRW	SB


DRAWING APPROVALS	
DRAWN	DATE
LDC	01/05/24
CHECKED	DATE
GJR	01/17/24
ENGINEER	DATE
SB	01/18/24

HORIZONTAL SCALE: 1"=400'


VERTICAL SCALE: 1"=40'

CHPE - LAKE CHAMPLAIN PROPOSED CABLE ROUTE
EM&CP SEGMENT 18B
PLAN & PROFILE STA 1772+96.00 TO STA 1899+60.00

SCALE	PROJECT NO.	DRAWING NO.	SHT. NO.
1"=400'	532345	C-15	21

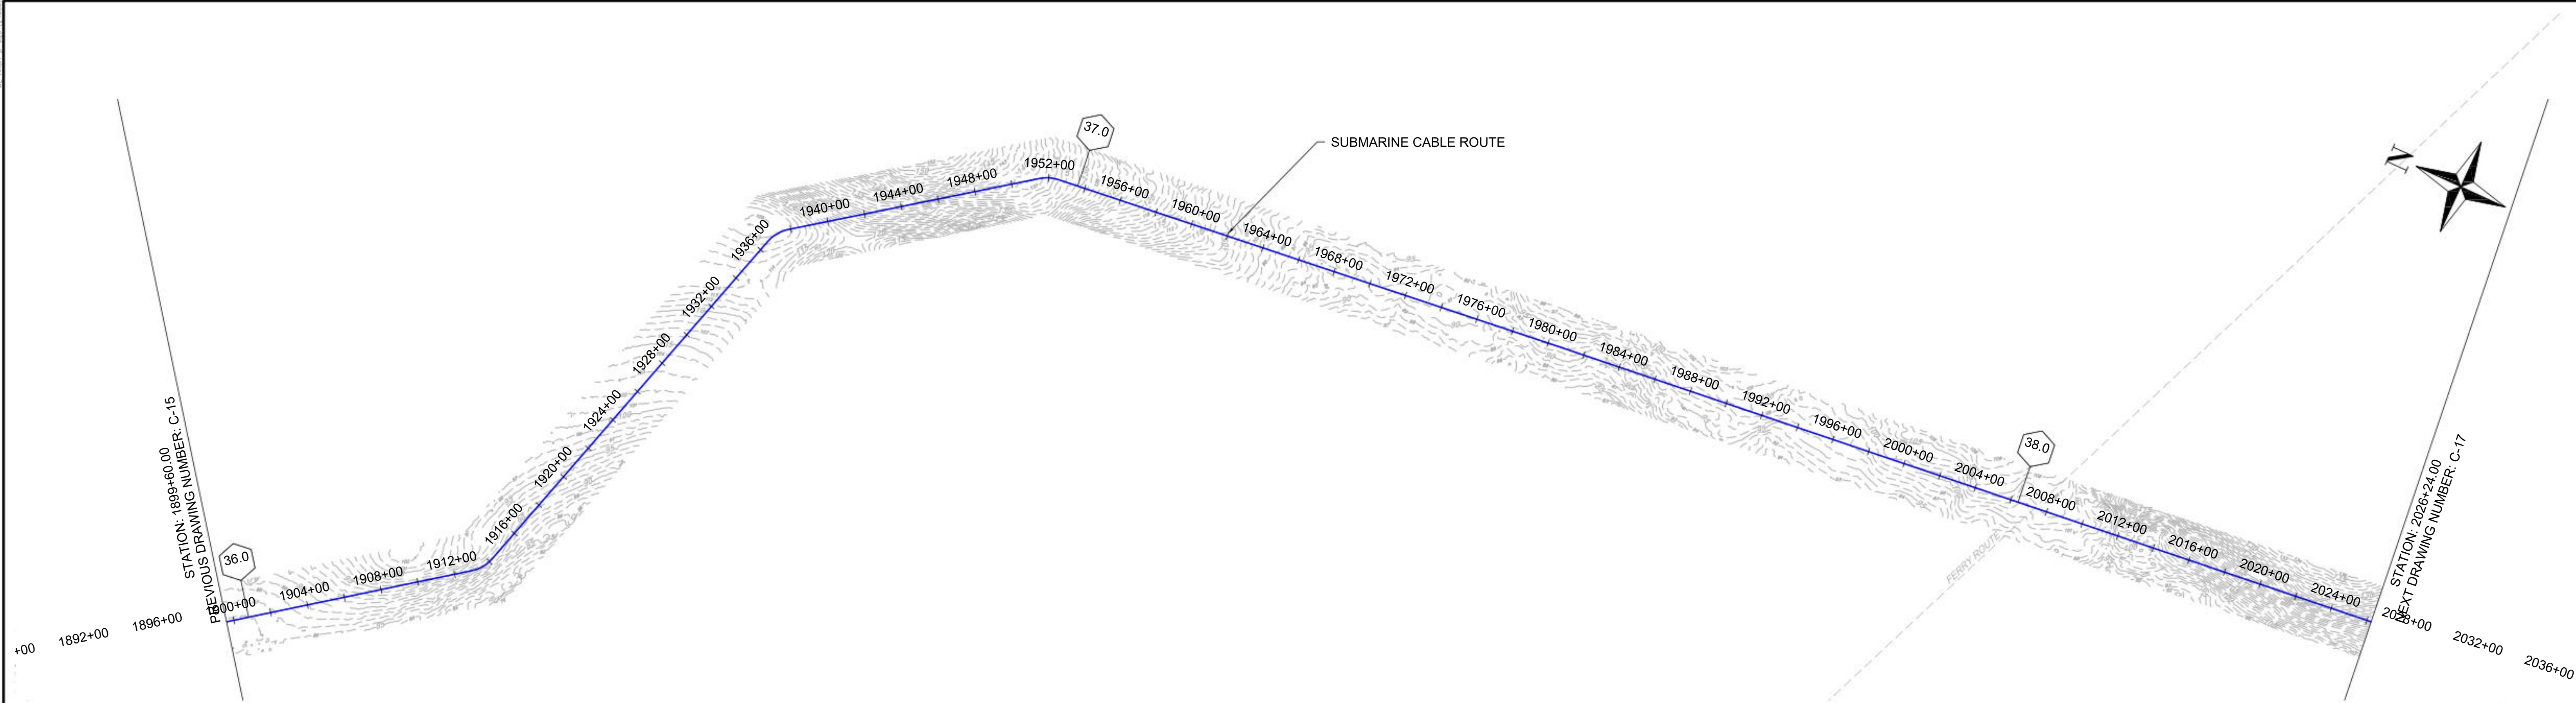

1 PLAN VIEW
SCALE: 1"=400'

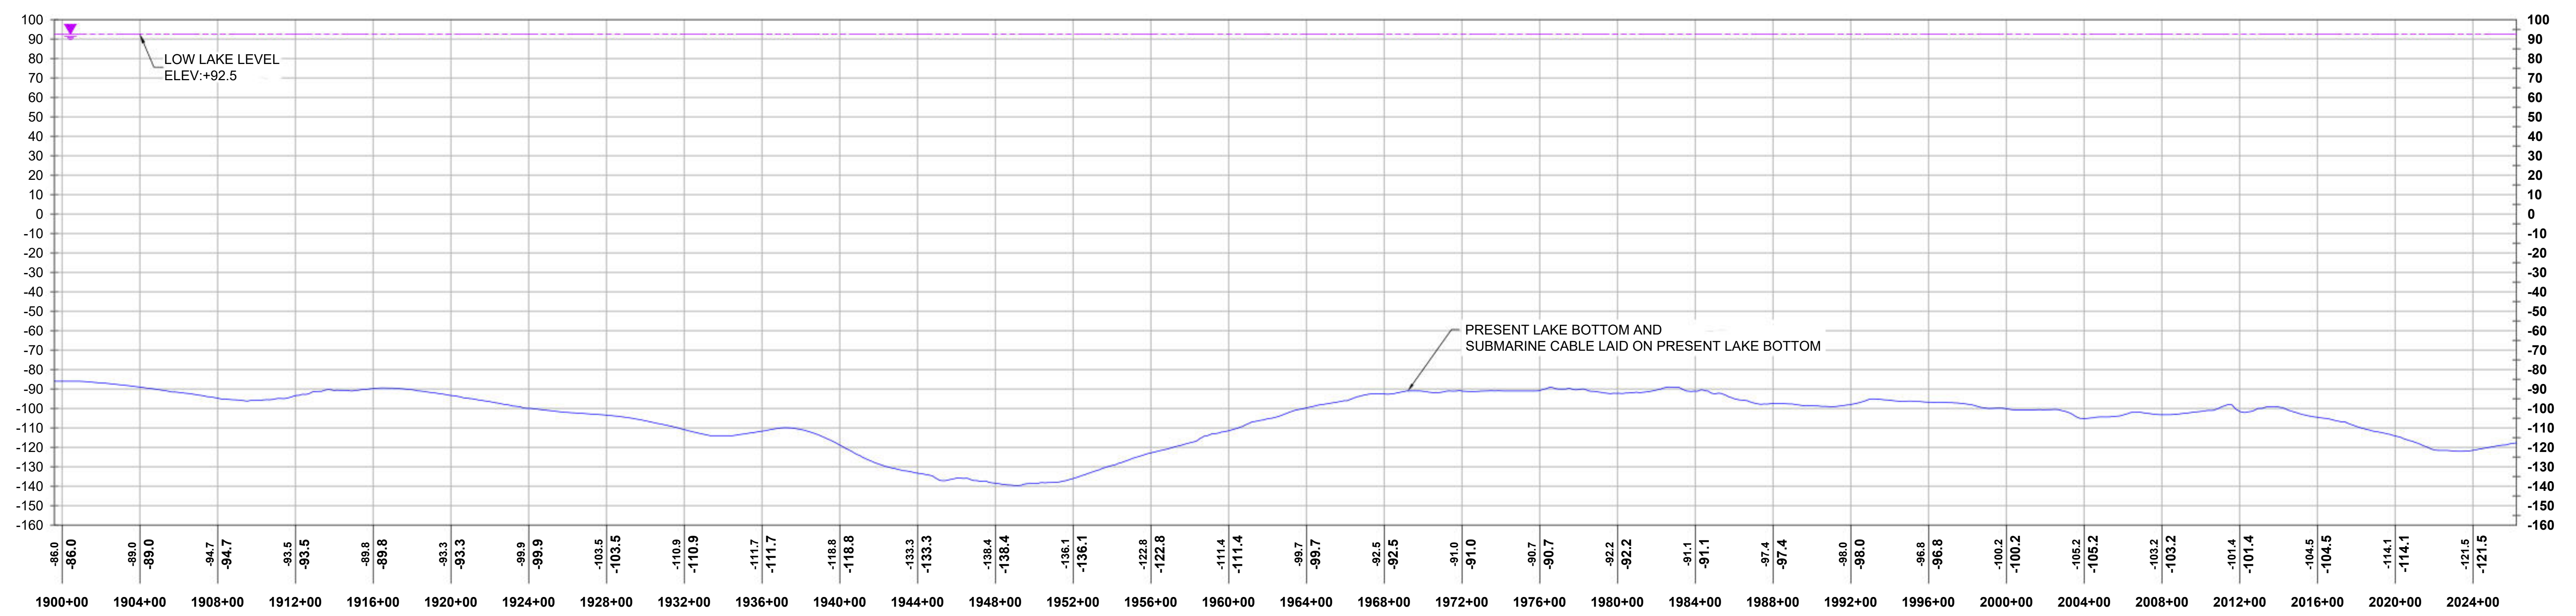

2 PROFILE VIEW
HORIZONTAL SCALE: 1"=400', VERTICAL SCALE: 1"=40'



REFERENCE DRAWINGS	
DWG. NO.	TITLE


REVISIONS					
NO.	DESCRIPTION	DATE	DRAWN	CHK	APPR
1	LLL ADDED PER NYS OPS REQUEST	03/29/2024	EYA	PRW	SB

DRAWING APPROVALS	
DRAWN	DATE
LDC	01/05/24
CHECKED	DATE
GJR	01/17/24
ENGINEER	DATE
SB	01/18/24


HORIZONTAL SCALE: 0 400'

VERTICAL SCALE: 0 40'

CHPE - LAKE CHAMPLAIN PROPOSED CABLE ROUTE EM&CP SEGMENT 18B PLAN & PROFILE STA 1899+60.00 TO STA 2026+24.00			
SCALE	PROJECT NO.	DRAWING NO.	SHT. NO.
1"=400'	532345	C-16	22

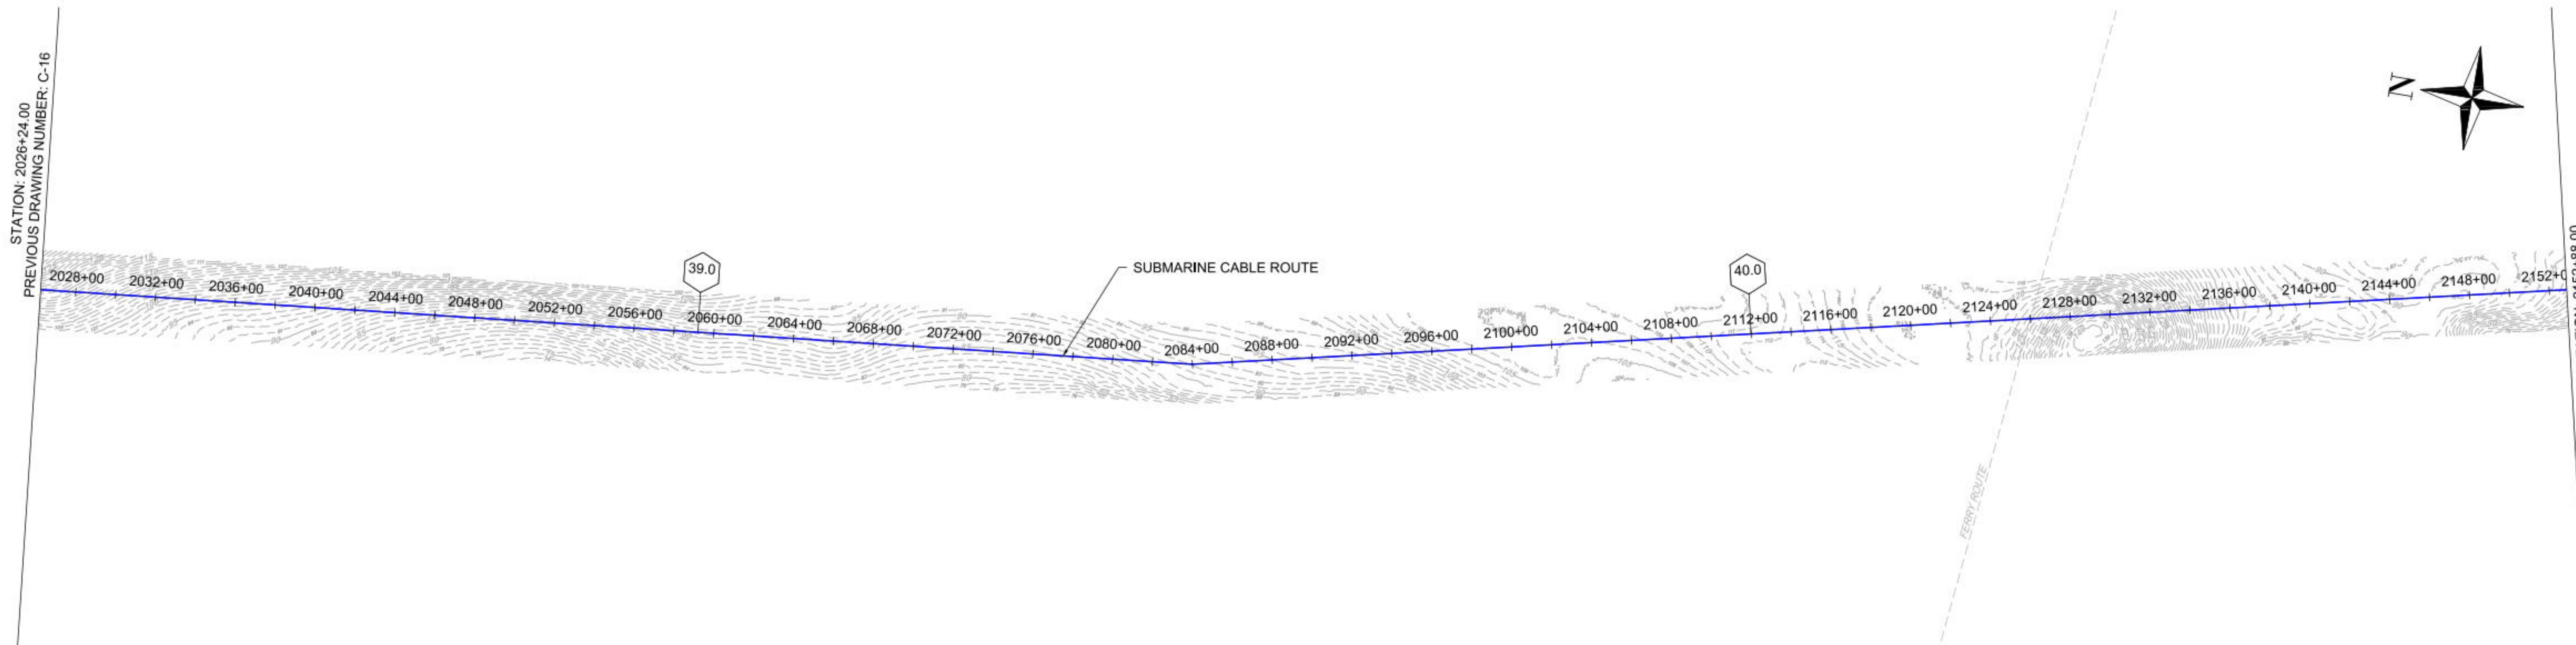

1 PLAN VIEW
SCALE: 1"=400'

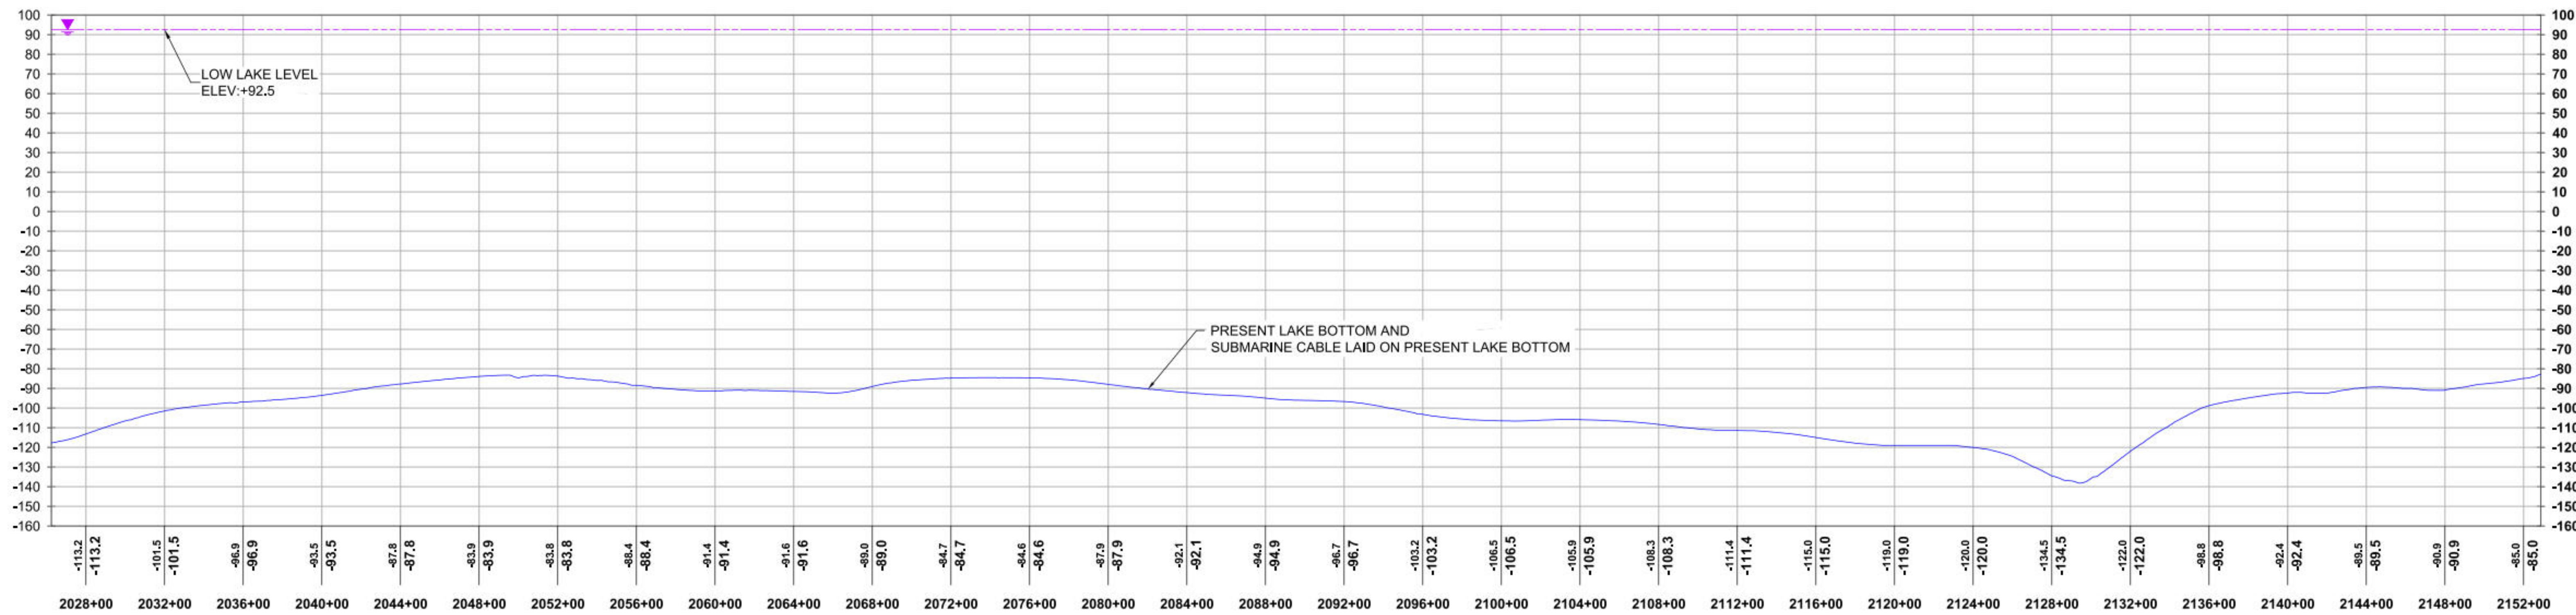

2 PROFILE VIEW
HORIZONTAL SCALE: 1"=400', VERTICAL SCALE: 1"=40'



Sharon L. Burke

REFERENCE DRAWINGS


DWG. NO.	TITLE

REVISIONS

NO.	DESCRIPTION	DATE	DRAWN	CHK	APPR
1	LLL ADDED PER NYS DPS REQUEST	03/29/2024	EYA	PRW	SB


DRAWING APPROVALS

DRAWN	DATE
LDC	01/05/24
CHECKED	DATE
GJR	01/17/24
ENGINEER	DATE
SB	01/18/24

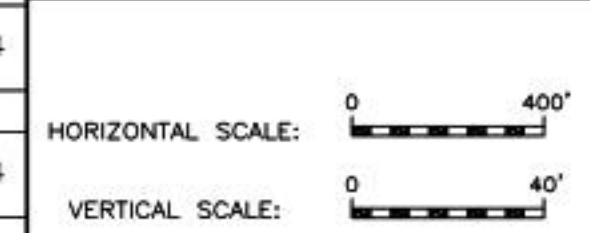


CHPE - LAKE CHAMPLAIN PROPOSED CABLE ROUTE
EM&CP SEGMENT 18B
PLAN & PROFILE STA 2026+24.00 TO STA 2152+88.00

SCALE	PROJECT NO.	DRAWING NO.	SHT. NO.
1"=400'	532345	C-17	23

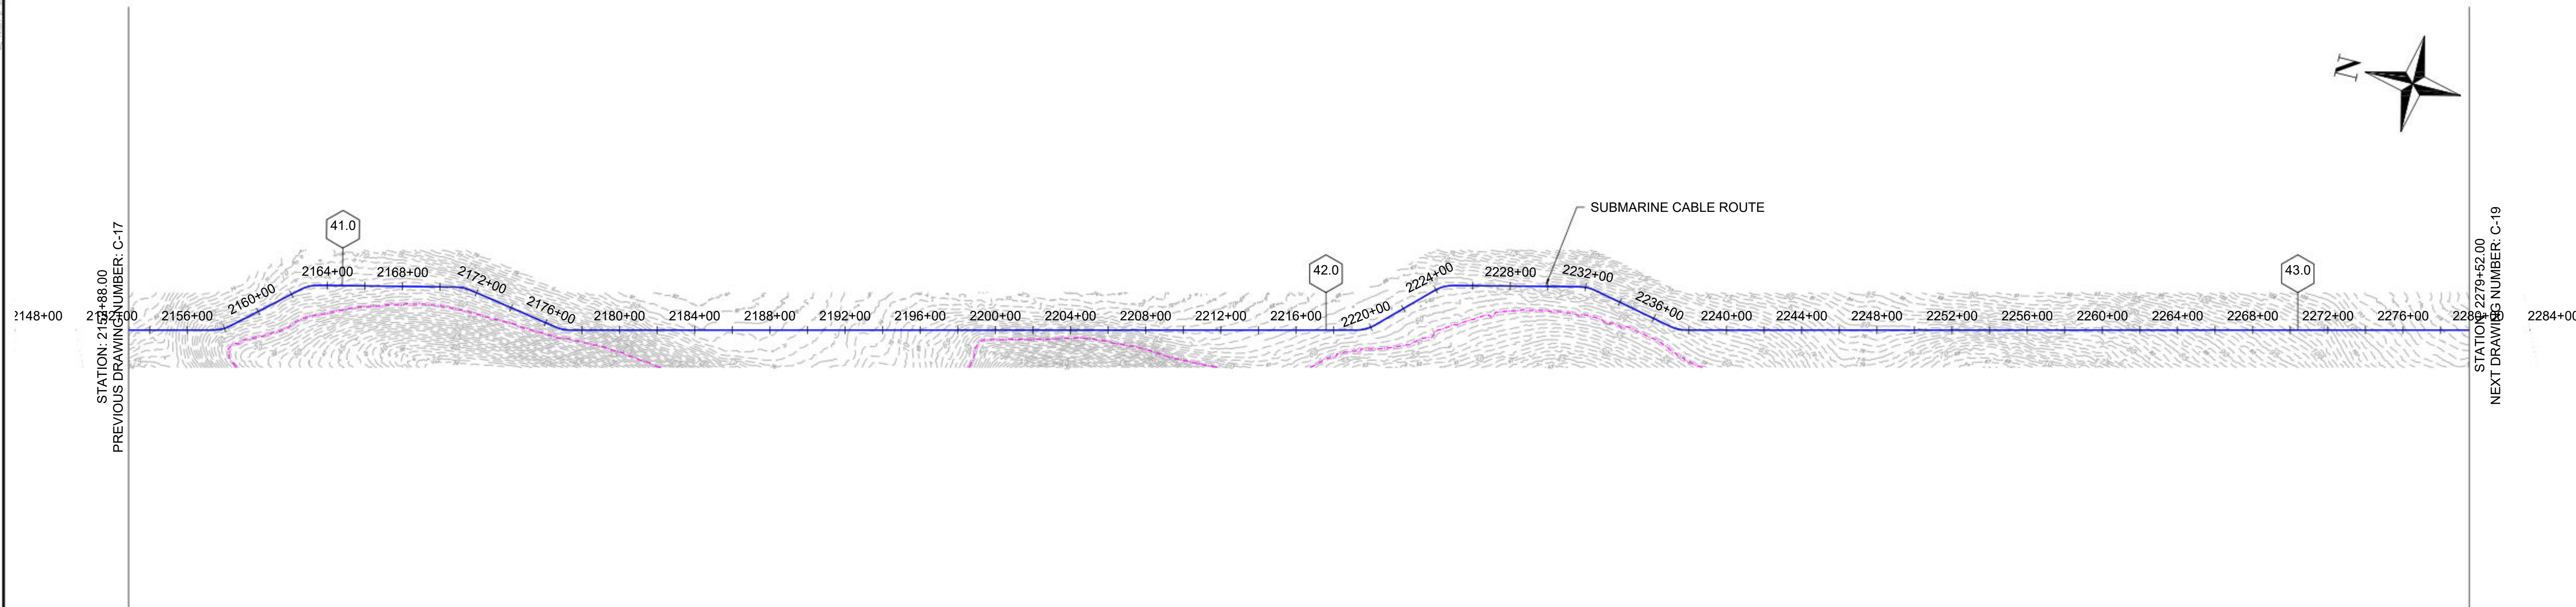

1 PLAN VIEW
SCALE: 1"=400'

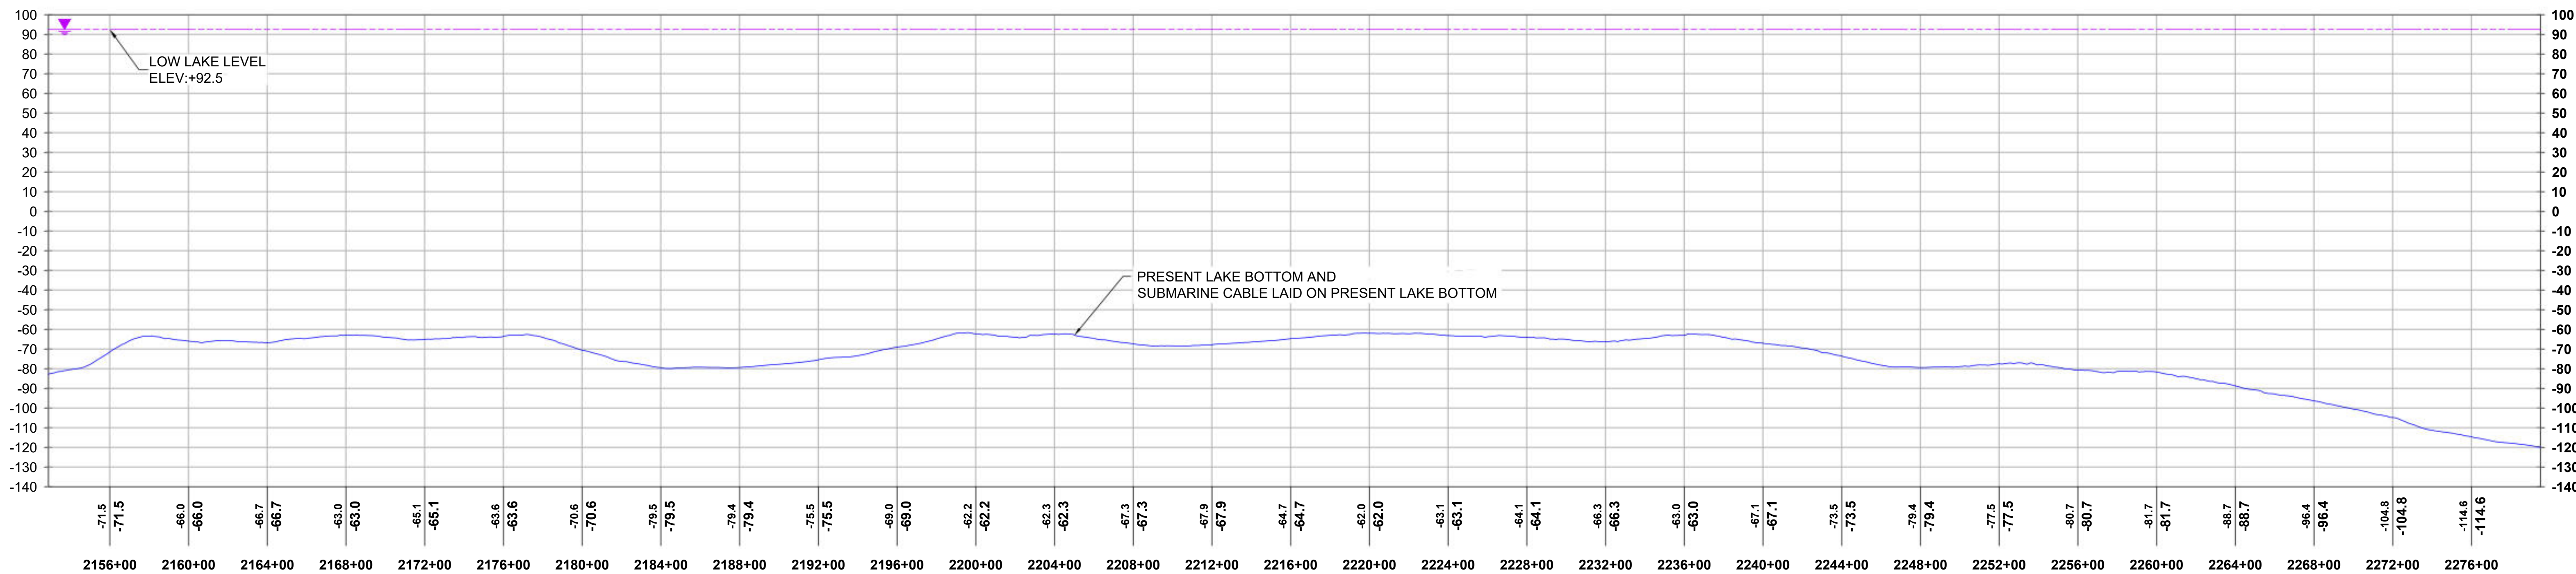

2 PROFILE VIEW
HORIZONTAL SCALE: 1"=400', VERTICAL SCALE: 1"=40'



REFERENCE DRAWINGS	
DWG. NO.	TITLE

REVISIONS					
NO.	DESCRIPTION	DATE	DRAWN	CHK	APPR
1	LLL ADDED PER NYS DPS REQUEST	03/29/2024	EYA	PRW	SB

DRAWING APPROVALS	
DRAWN	DATE
LDC	01/05/24
CHECKED	DATE
GJR	01/17/24
ENGINEER	DATE
SB	01/18/24

HORIZONTAL SCALE: 0 400'

VERTICAL SCALE: 0 40'

CHPE - LAKE CHAMPLAIN PROPOSED CABLE ROUTE EM&CP SEGMENT 18B PLAN & PROFILE STA 2152+88.00 TO STA 2279+52.00			
SCALE	PROJECT NO.	DRAWING NO.	SHT. NO.
1"=400'	532345	C-18	24